



**UHLEIN
WILSON**
ARCHITECTS

322 East Michigan Street
Milwaukee, WI 53202

telephone | 414.271.8899
facsimile | 414.271.8942
email | office@uhllein-wilson.com

© UHLEIN WILSON ARCHITECTS, INC. ALL RIGHTS RESERVED
THIS SHEET IS THE PROPERTY OF UHLEIN WILSON ARCHITECTS, INC. IT IS TO BE USED ONLY FOR THE PROJECT AND SITE SPECIFICALLY IDENTIFIED HEREON. IT IS NOT TO BE REPRODUCED, COPIED, OR TRANSMITTED IN ANY FORM OR BY ANY MEANS, ELECTRONIC OR MECHANICAL, INCLUDING PHOTOCOPYING, RECORDING, OR BY ANY INFORMATION STORAGE AND RETRIEVAL SYSTEM, WITHOUT THE WRITTEN PERMISSION OF UHLEIN WILSON ARCHITECTS, INC.

REVISIONS			
NO.	DATE	ISSUE	

PROJECT



Proposed MSOE
SOCCER & PARKING
FACILITY

SHEET

COVER
DETAILED PLAN
DEVELOPMENT
SUBMITTAL

DATE


May 9, 2011

PROJECT NO.

09-117

SHEET NO.

A-001

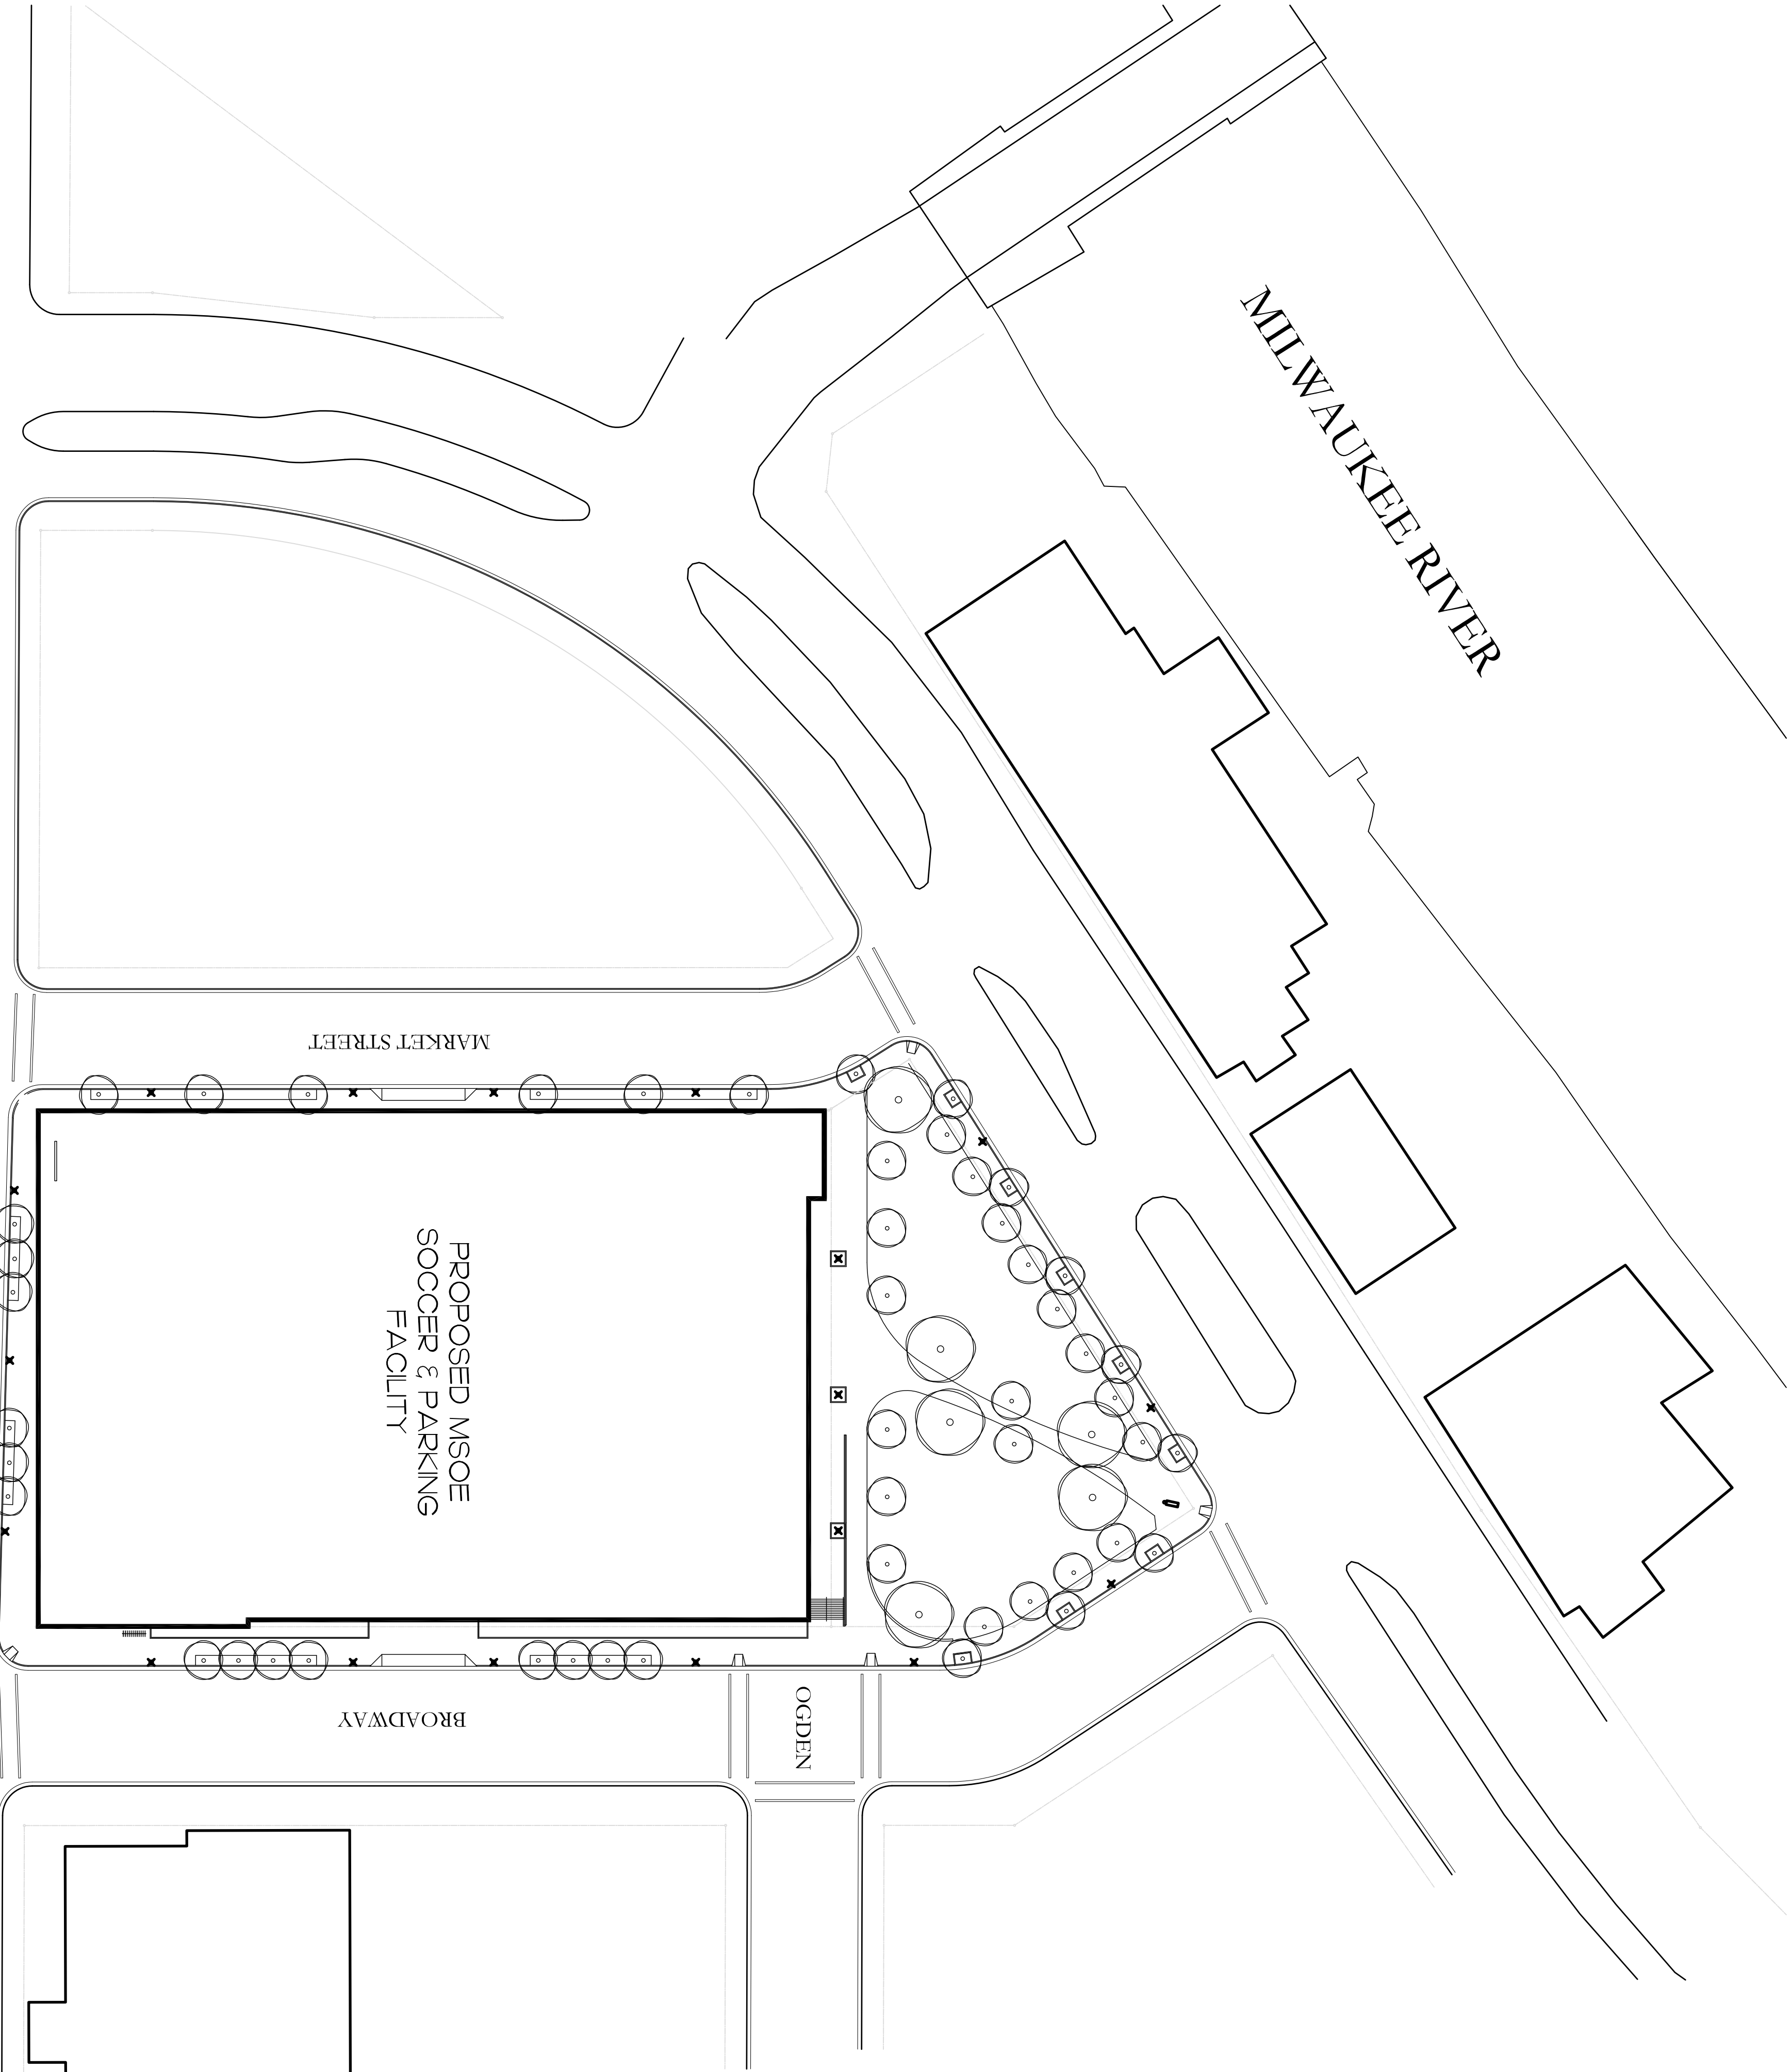

WATER STREET

KNAPP ST

MARKET STREET

BROADWAY

OGDEN

MILWAUKEE RIVER

DRAWING INDEX

A-001	COVER
C-102	SITE PLAN
C-103	SITE GEOMETRIC PLAN
C-104	SITE GRADING PLAN
C-105	SITE UTILITY PLAN
E-100	LIGHTING
E-101	FIELD LEVEL PHOTOMETRICS
L-101	SITE LANDSCAPE PLAN
A-100	LOWER LEVEL
A-101	MARKET LEVEL PLAN
A-102	BROADWAY LEVEL PLAN
A-103	FIELD LEVEL PLAN
A-200	ELEVATIONS
A-201	SIGNAGE
A-300	SECTIONS


SITE LOCATION

1" = 50' 0"

1



HATCH LEGEND	PAVEMENT MARKING LEGEND
AREAS DISTURBED BY CONSTRUCTION (NOT SPECIFICALLY CALLED OUT ON THE LANDSCAPE PLANS) TO BE RESTORED WITH MINIMUM 4" TOPSOIL, SEED, FERTILIZER, AND MULCH (TYP). USE SALVAGED TOPSOIL OR IMPORT TOPSOIL IF REQUIRED.	A PAVEMENT MARKING ARROWS, EPOXY TYPE 2 OR 3, WHITE (SEE WDOT PAVEMENT MARKING S.D.D.)
NEW CONCRETE PAVING SEE DETAIL ----/-----	B PAVEMENT MARKING WORDS, EPOXY, WHITE (SEE WDOT PAVEMENT MARKING S.D.D.)
NEW HIGH-SIDE CURB & GUTTER SEE DETAIL ----/-----	C PAVEMENT MARKING STOP LINE, EPOXY, WHITE (SEE WDOT PAVEMENT MARKING S.D.D.)
NEW LOW-SIDE CURB & GUTTER SEE DETAIL ----/-----	D PAVEMENT MARKING MAINLINE, EPOXY, 4" YELLOW (DOUBLE) (SEE WDOT PAVEMENT MARKING S.D.D.)
	E PAVEMENT MARKING INTERSECTION, EPOXY, 4" WHITE (SEE WDOT PAVEMENT MARKING S.D.D.)
	F PAVEMENT MARKING CROSSWALK, EPOXY, WHITE, 4-INCH WIDE DIAGONAL STRIPING, 3' O.C. SPACING

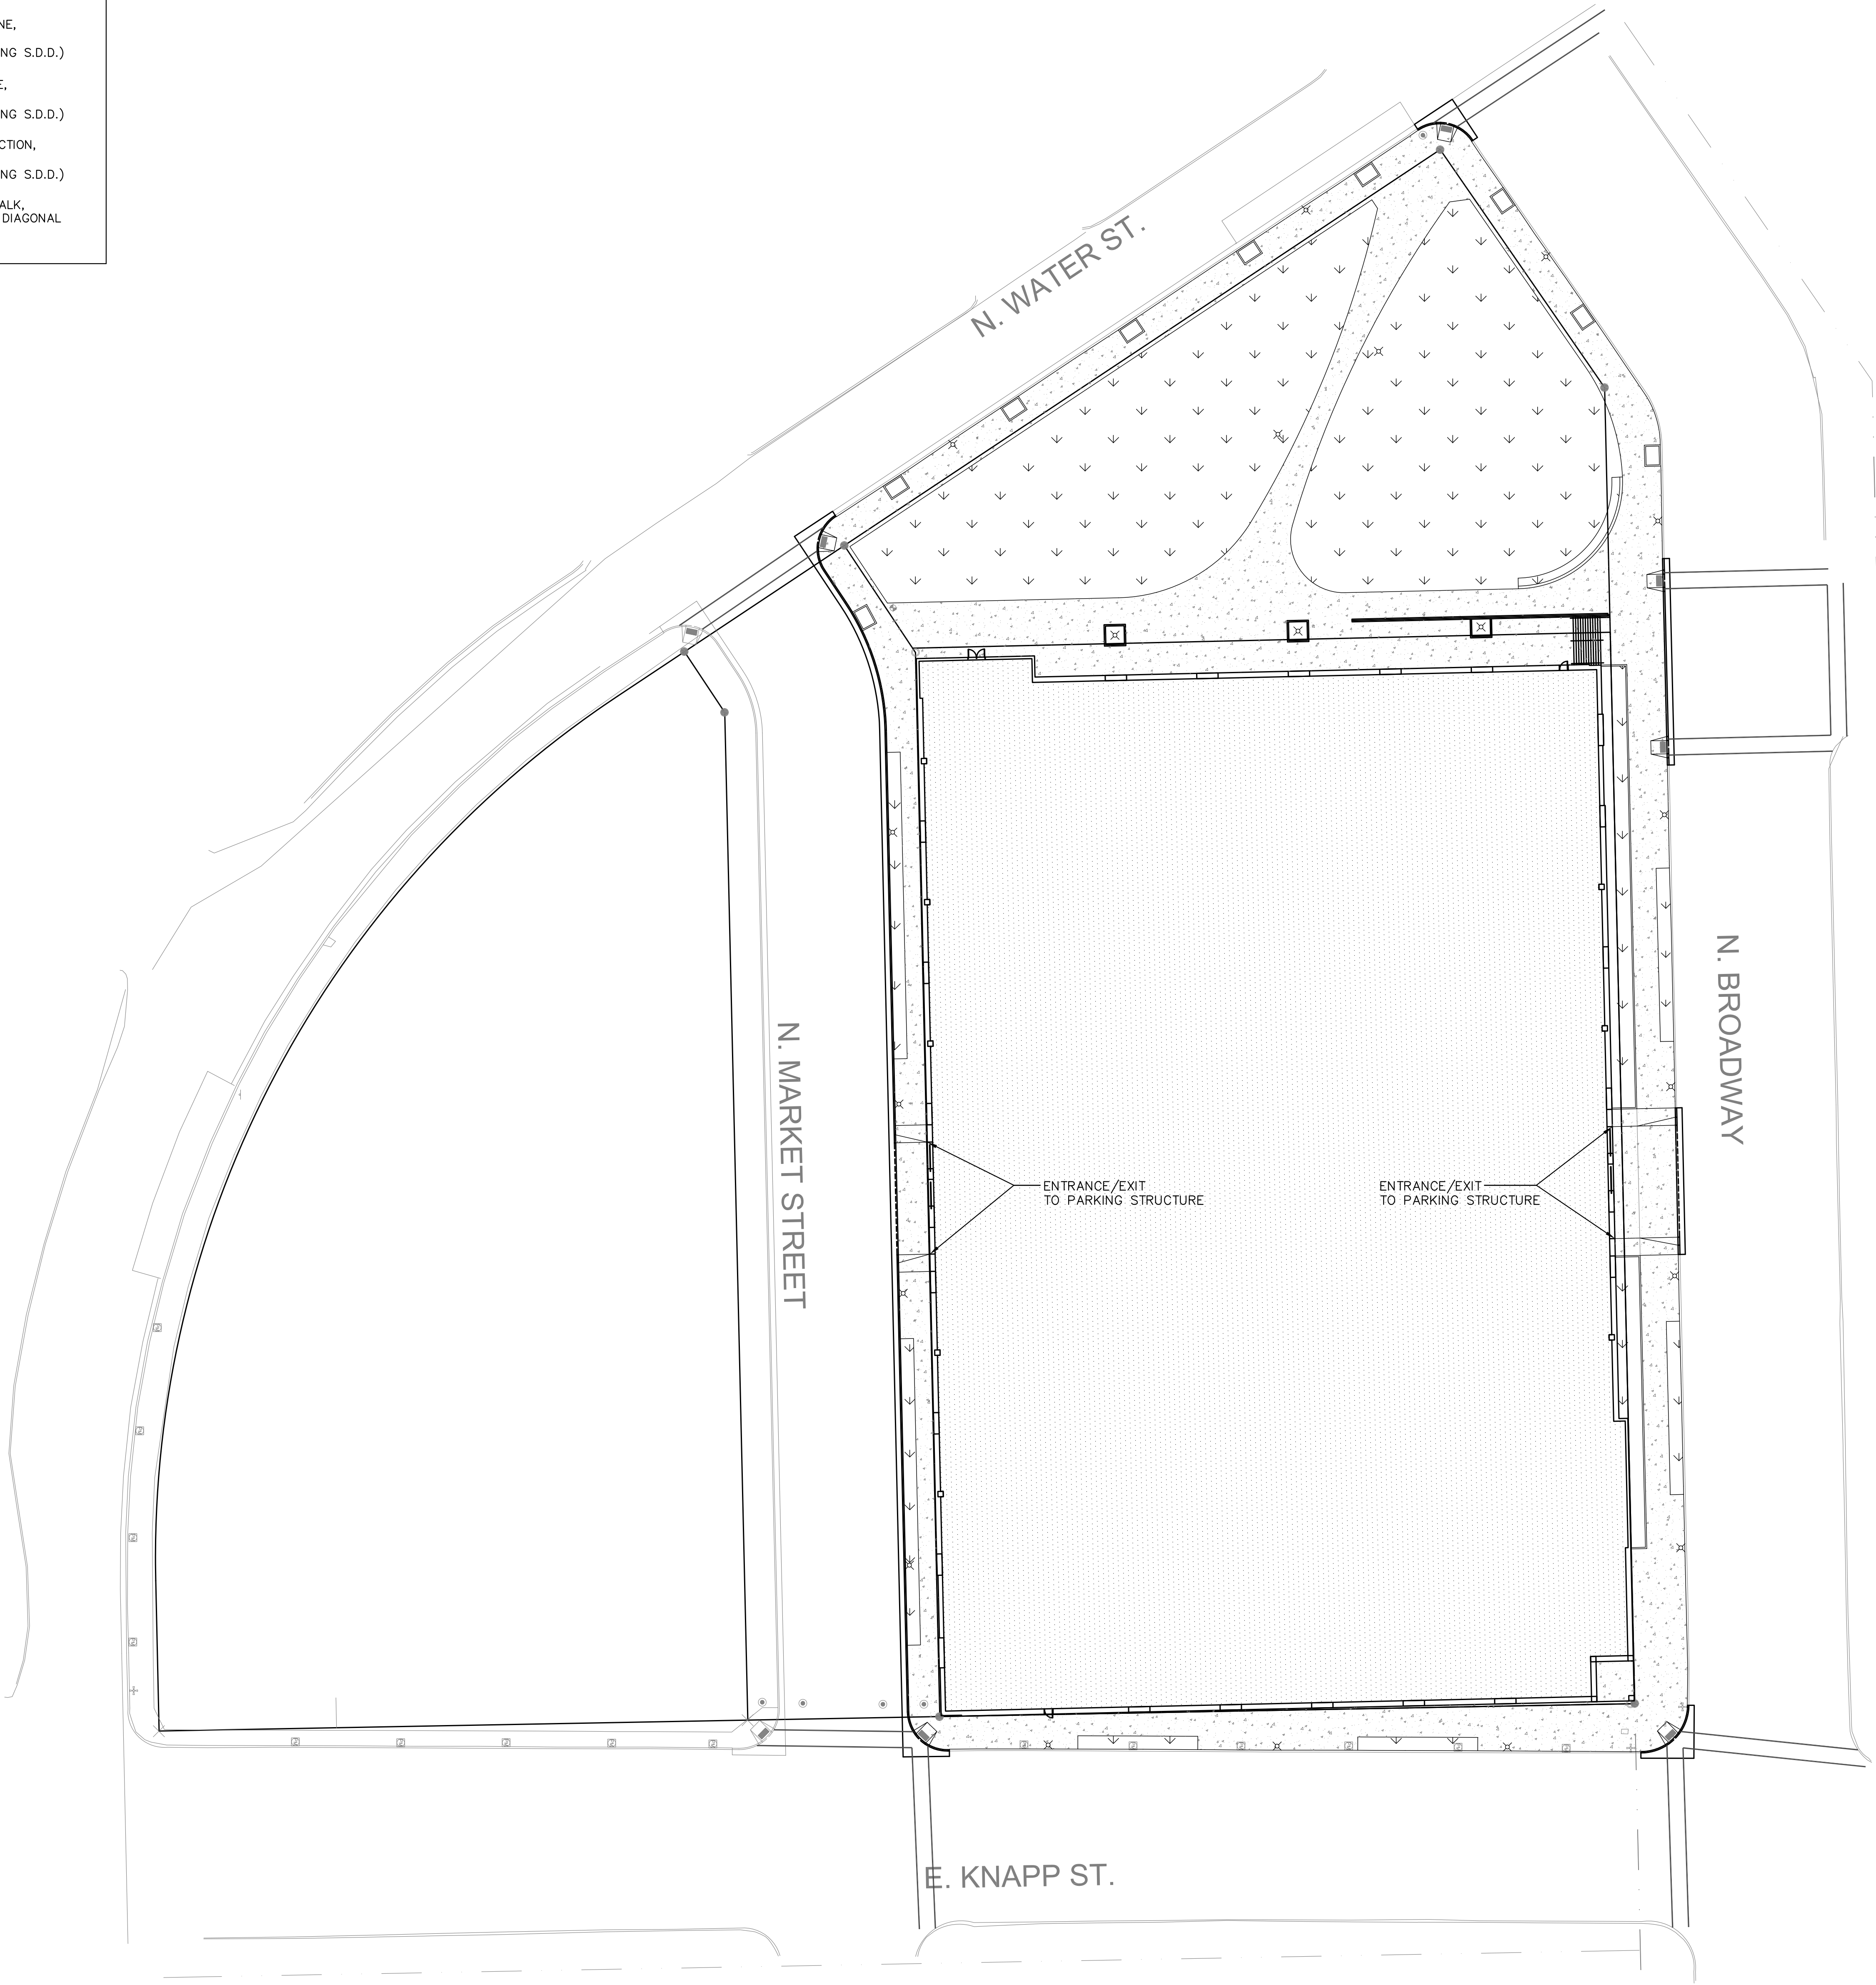

Toll Free (800) 242-8511
Milwaukee Area (414) 259-1181
Hearing Impaired TDD (800) 542-2289
www.DiggersHotline.com



UIHLEIN
WILSON
ARCHITECTS

322 East Michigan Street
Milwaukee, WI 53202

telephone | 414.271.8899
facsimile | 414.271.8942
email | office@uihlein-wilson.com

© UIHLEIN WILSON ARCHITECTS, INC. ALL RIGHTS RESERVED

OWNERSHIP OF DOCUMENTS
This document, and the ideas and designs incorporated herein, are
the property of Uihlein Wilson Architects, Inc., and it is not to be used in whole or in part
for any other project or purpose without the expressed written
authorization of Uihlein Wilson Architects, Inc.

REVISIONS

NO.	DATE	ISSUE
-----	------	-------

PROJECT



Proposed MSOE
SOCCER & PARKING
FACILITY

SHEET

SITE PLAN

DATE

May 09, 2011

PROJECT NO.

09-117

SHEET NO.

C102



UIHLEIN WILSON ARCHITECTS

322 East Michigan Street
Milwaukee, WI 53202

telephone | 414.271.8899
facsimile | 414.271.8942
email | office@uihlein-wilson.com

© UIHLEIN WILSON ARCHITECTS, INC. ALL RIGHTS RESERVED

OWNERSHIP OF DOCUMENTS
This document, and the ideas and designs incorporated herein, are
an instrument of professional service, and are the sole property of
Uihlein Wilson Architects, Inc., and it is not to be used in whole or in part
for any other project or purpose without the expressed written
authorization of Uihlein Wilson Architects, Inc.

REVISIONS

NO.	DATE	ISSUE
-----	------	-------

PROJECT



Proposed MSOE
SOCCER & PARKING
FACILITY

SHEET

SITE GEOMETRIC
PLAN

DATE



May 09, 2011

PROJECT NO.

09-117

SHEET NO.


C103

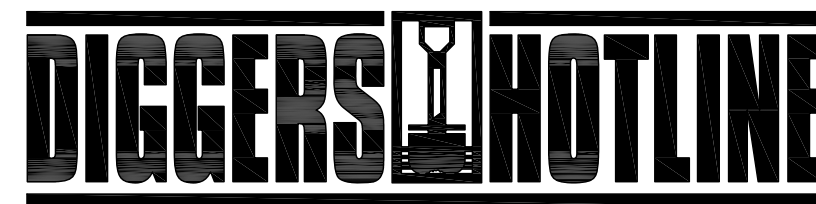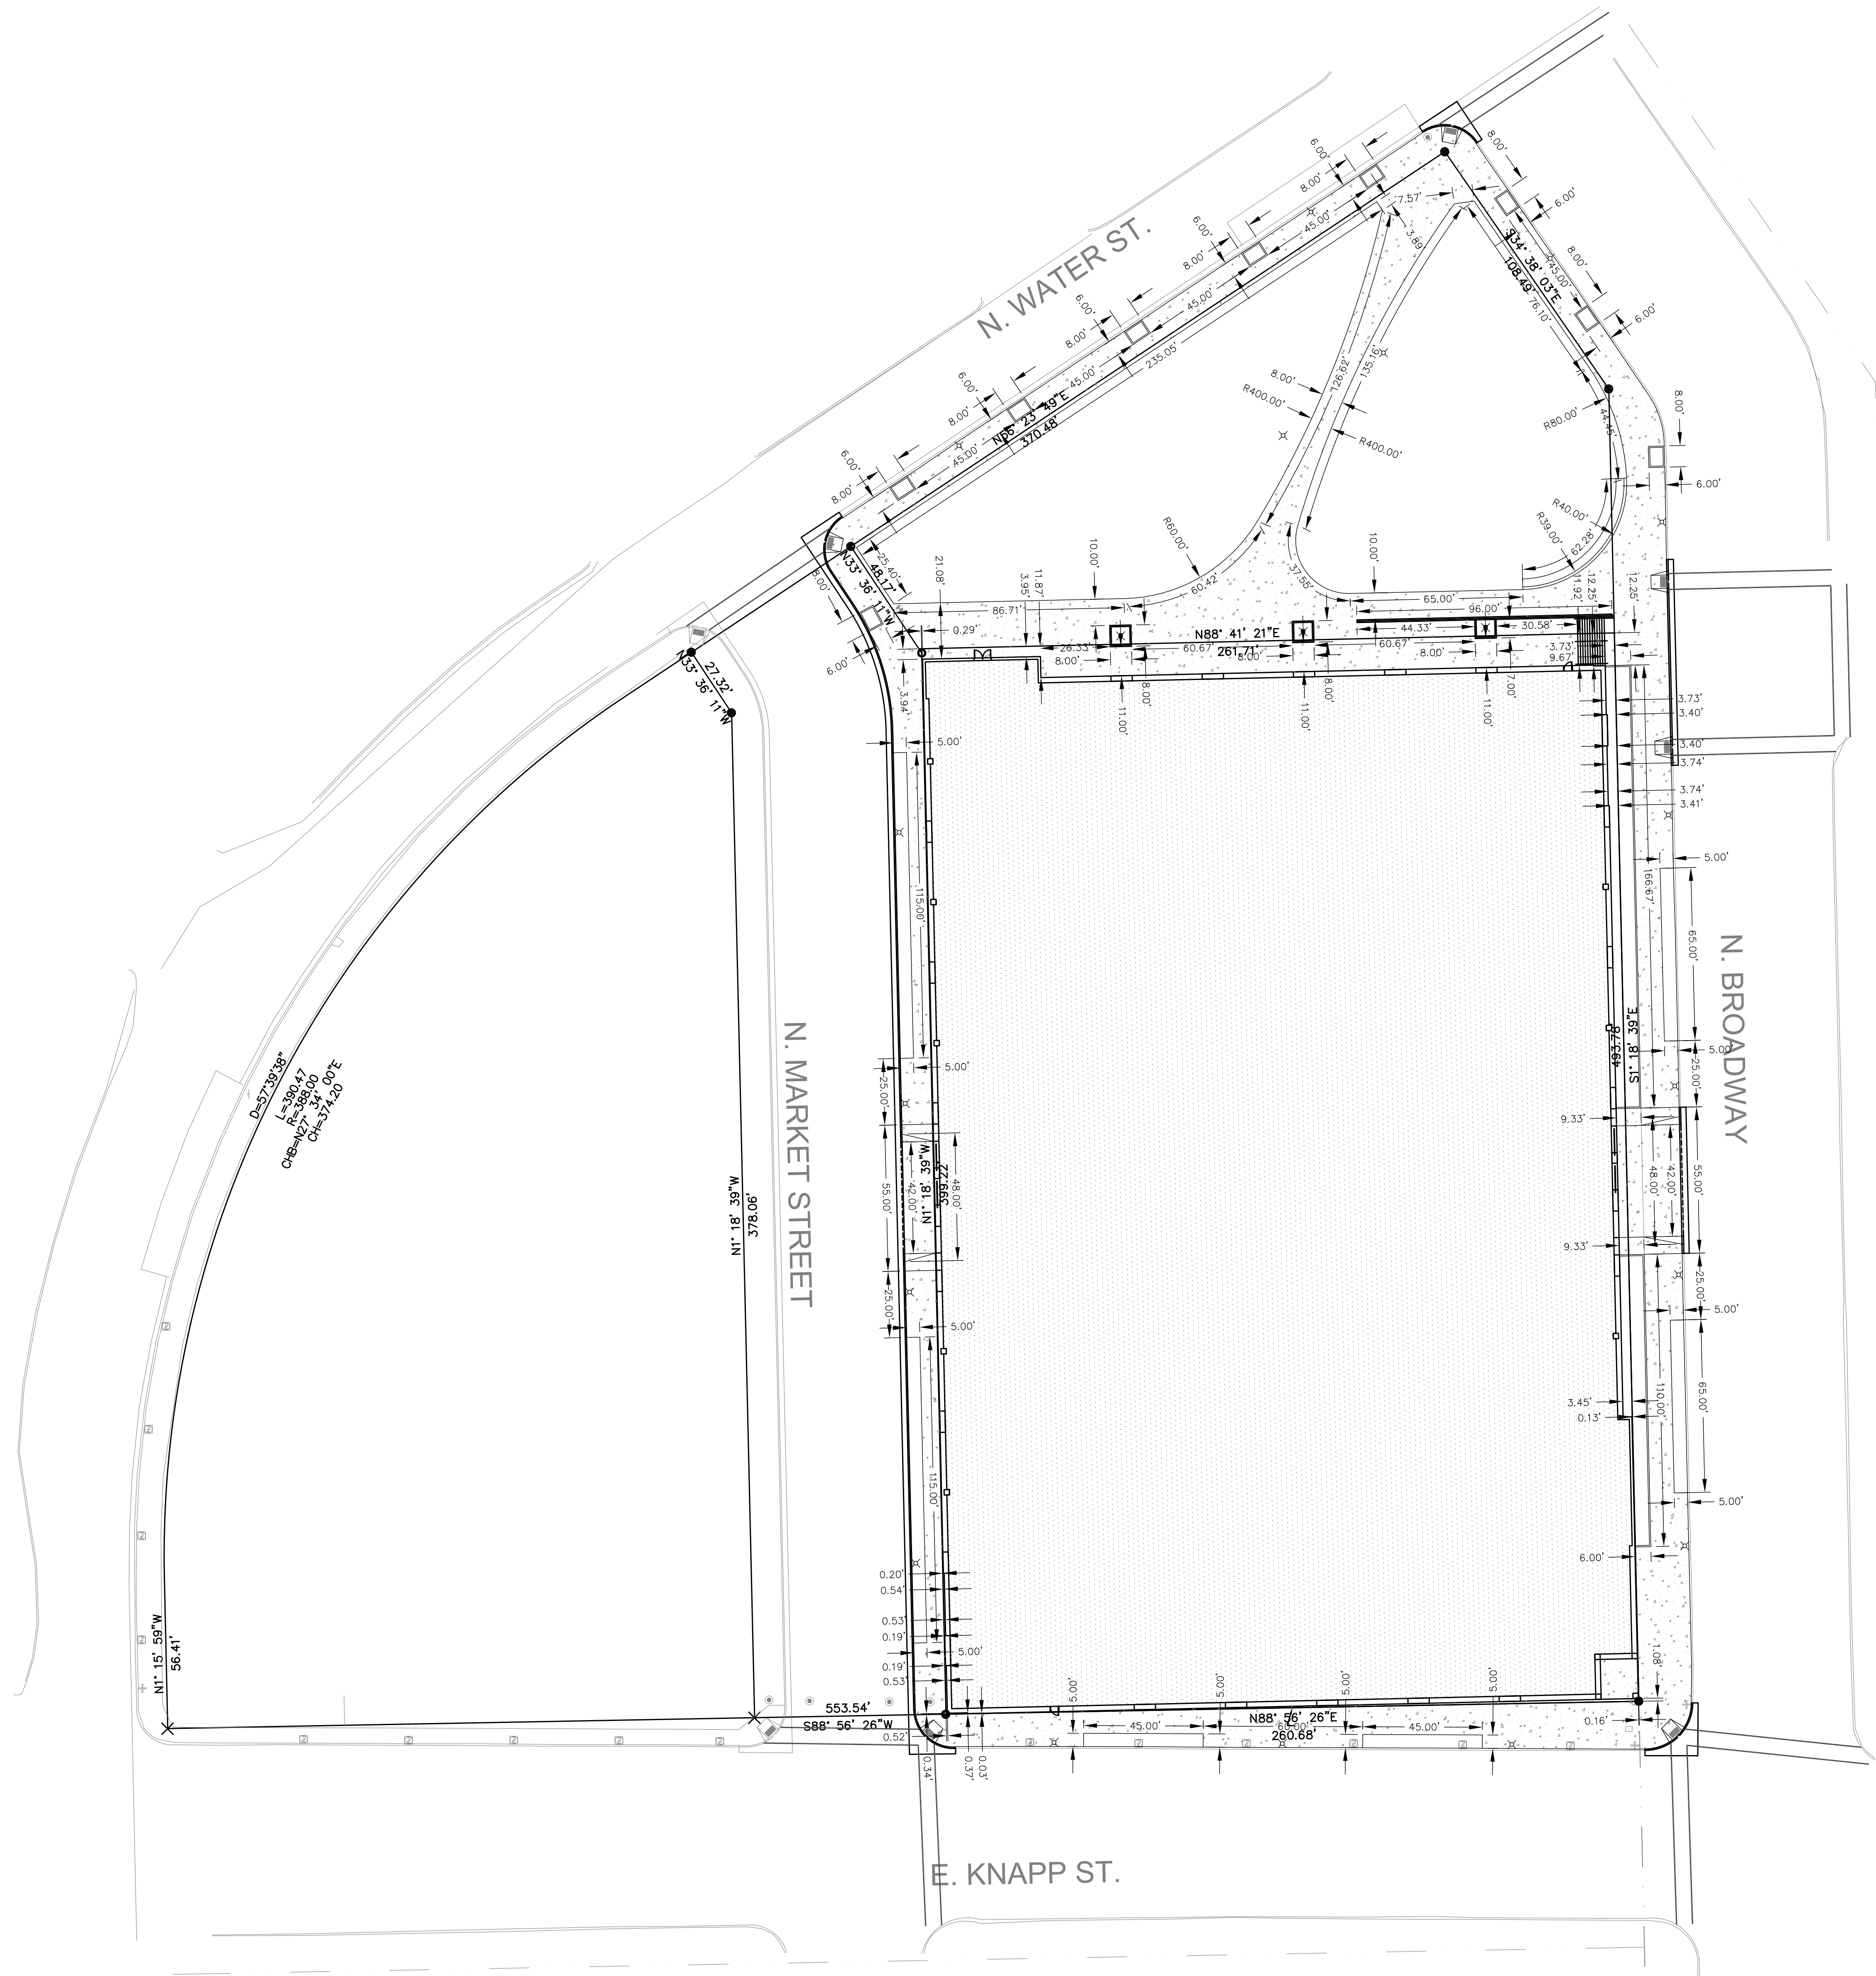

Toll Free (800) 242-8511
Milwaukee Area (414) 259-1181
Hearing Impaired TDD (800) 542-2289
www.DiggersHotline.com



GRADING LEGEND		
	11	EXISTING CONTOUR MINOR
	10	EXISTING CONTOUR MAJOR
	11	PROPOSED CONTOUR MINOR
	10	PROPOSED CONTOUR MAJOR
	10.45	PROPOSED SPOT GRADE
	T11.00	PROPOSED TOP OF CURB
	G10.50	PROPOSED BOTTOM OF CURB

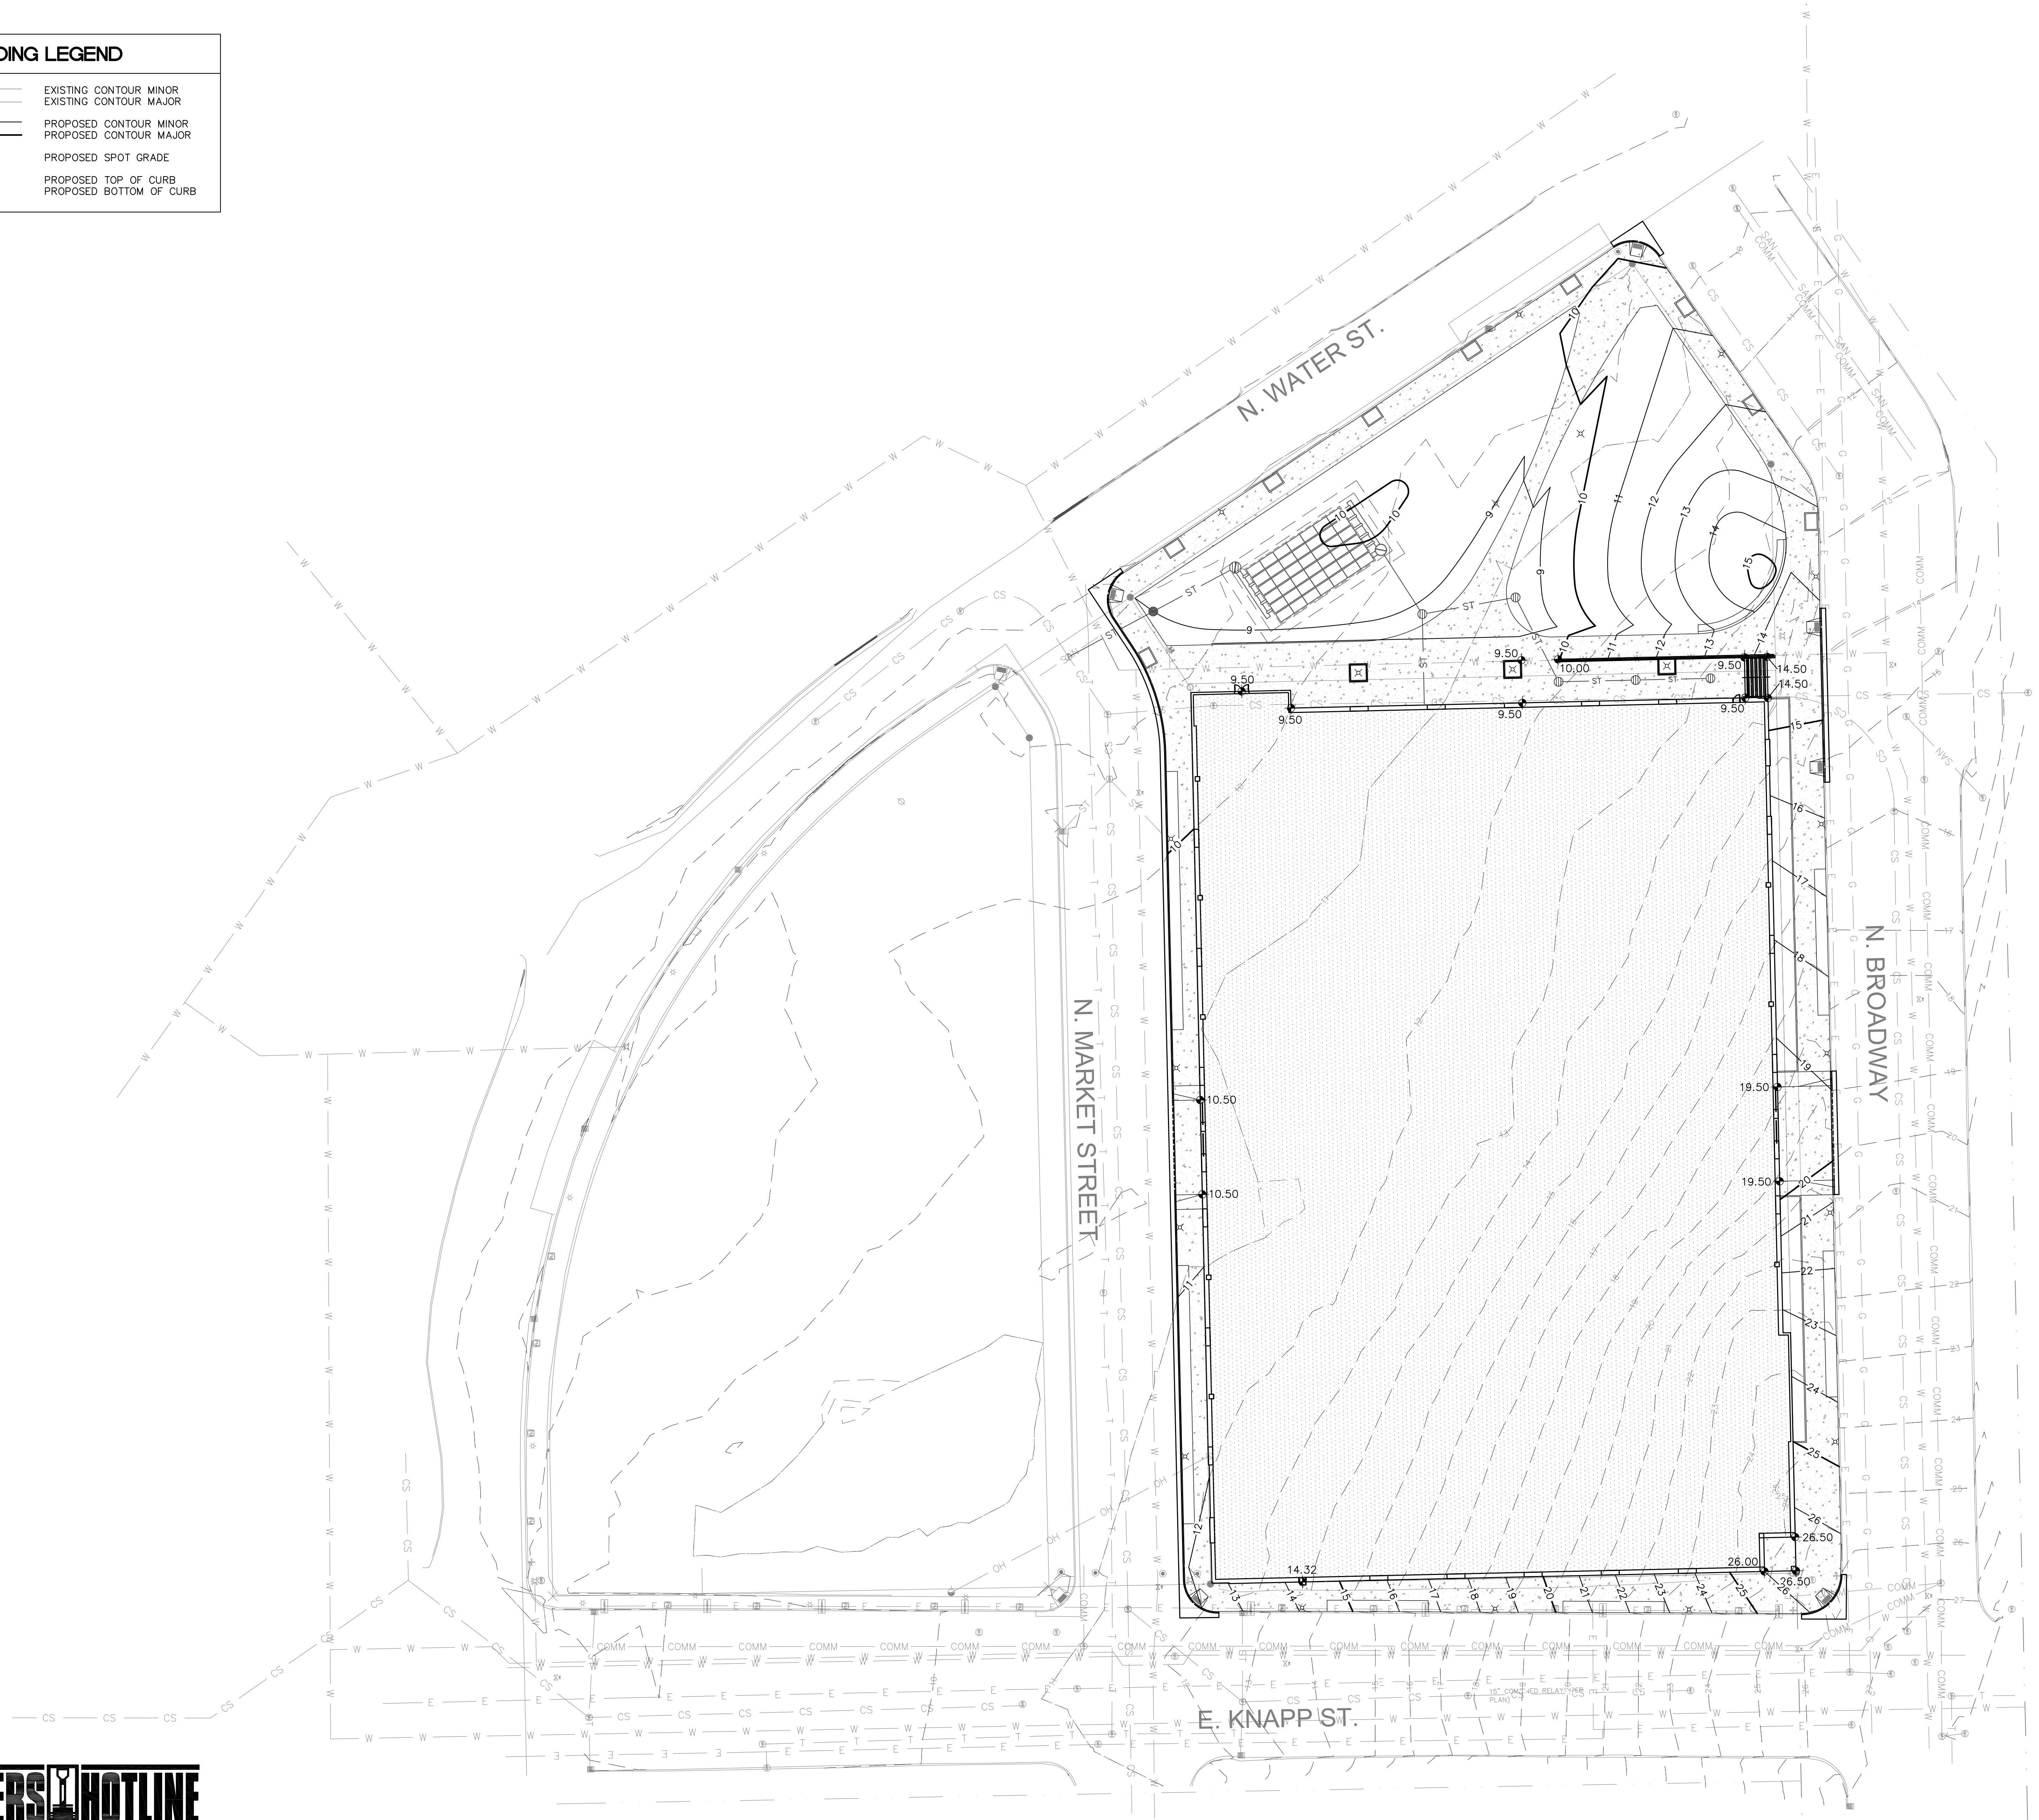

DIGGERSHOTLINE
Toll Free (800) 242-8511
Milwaukee Area (414) 259-1181
Hearing Impaired TDD (800) 542-2289
www.DiggersHotline.com



**UIHLEIN
WILSON**
ARCHITECTS

322 East Michigan Street
Milwaukee, WI 53202
telephone | 414.271.8899
facsimile | 414.271.8942
email | office@uihleין-wilson.com

© UIHLEIN WILSON ARCHITECTS, INC. ALL RIGHTS RESERVED
OWNERSHIP OF DOCUMENTS
This document, and the ideas and designs incorporated herein, are the property of Uihlein Wilson Architects, Inc., and it is not to be used in whole or in part for any other project or purpose without the expressed written authorization of Uihlein Wilson Architects, Inc.


REVISIONS		
NO.	DATE	ISSUE

PROJECT

Proposed MSOE
SOCCER & PARKING
FACILITY

SHEET
SITE GRADING PLAN

DATE
May 09, 2011
PROJECT NO.
09-117
SHEET NO.

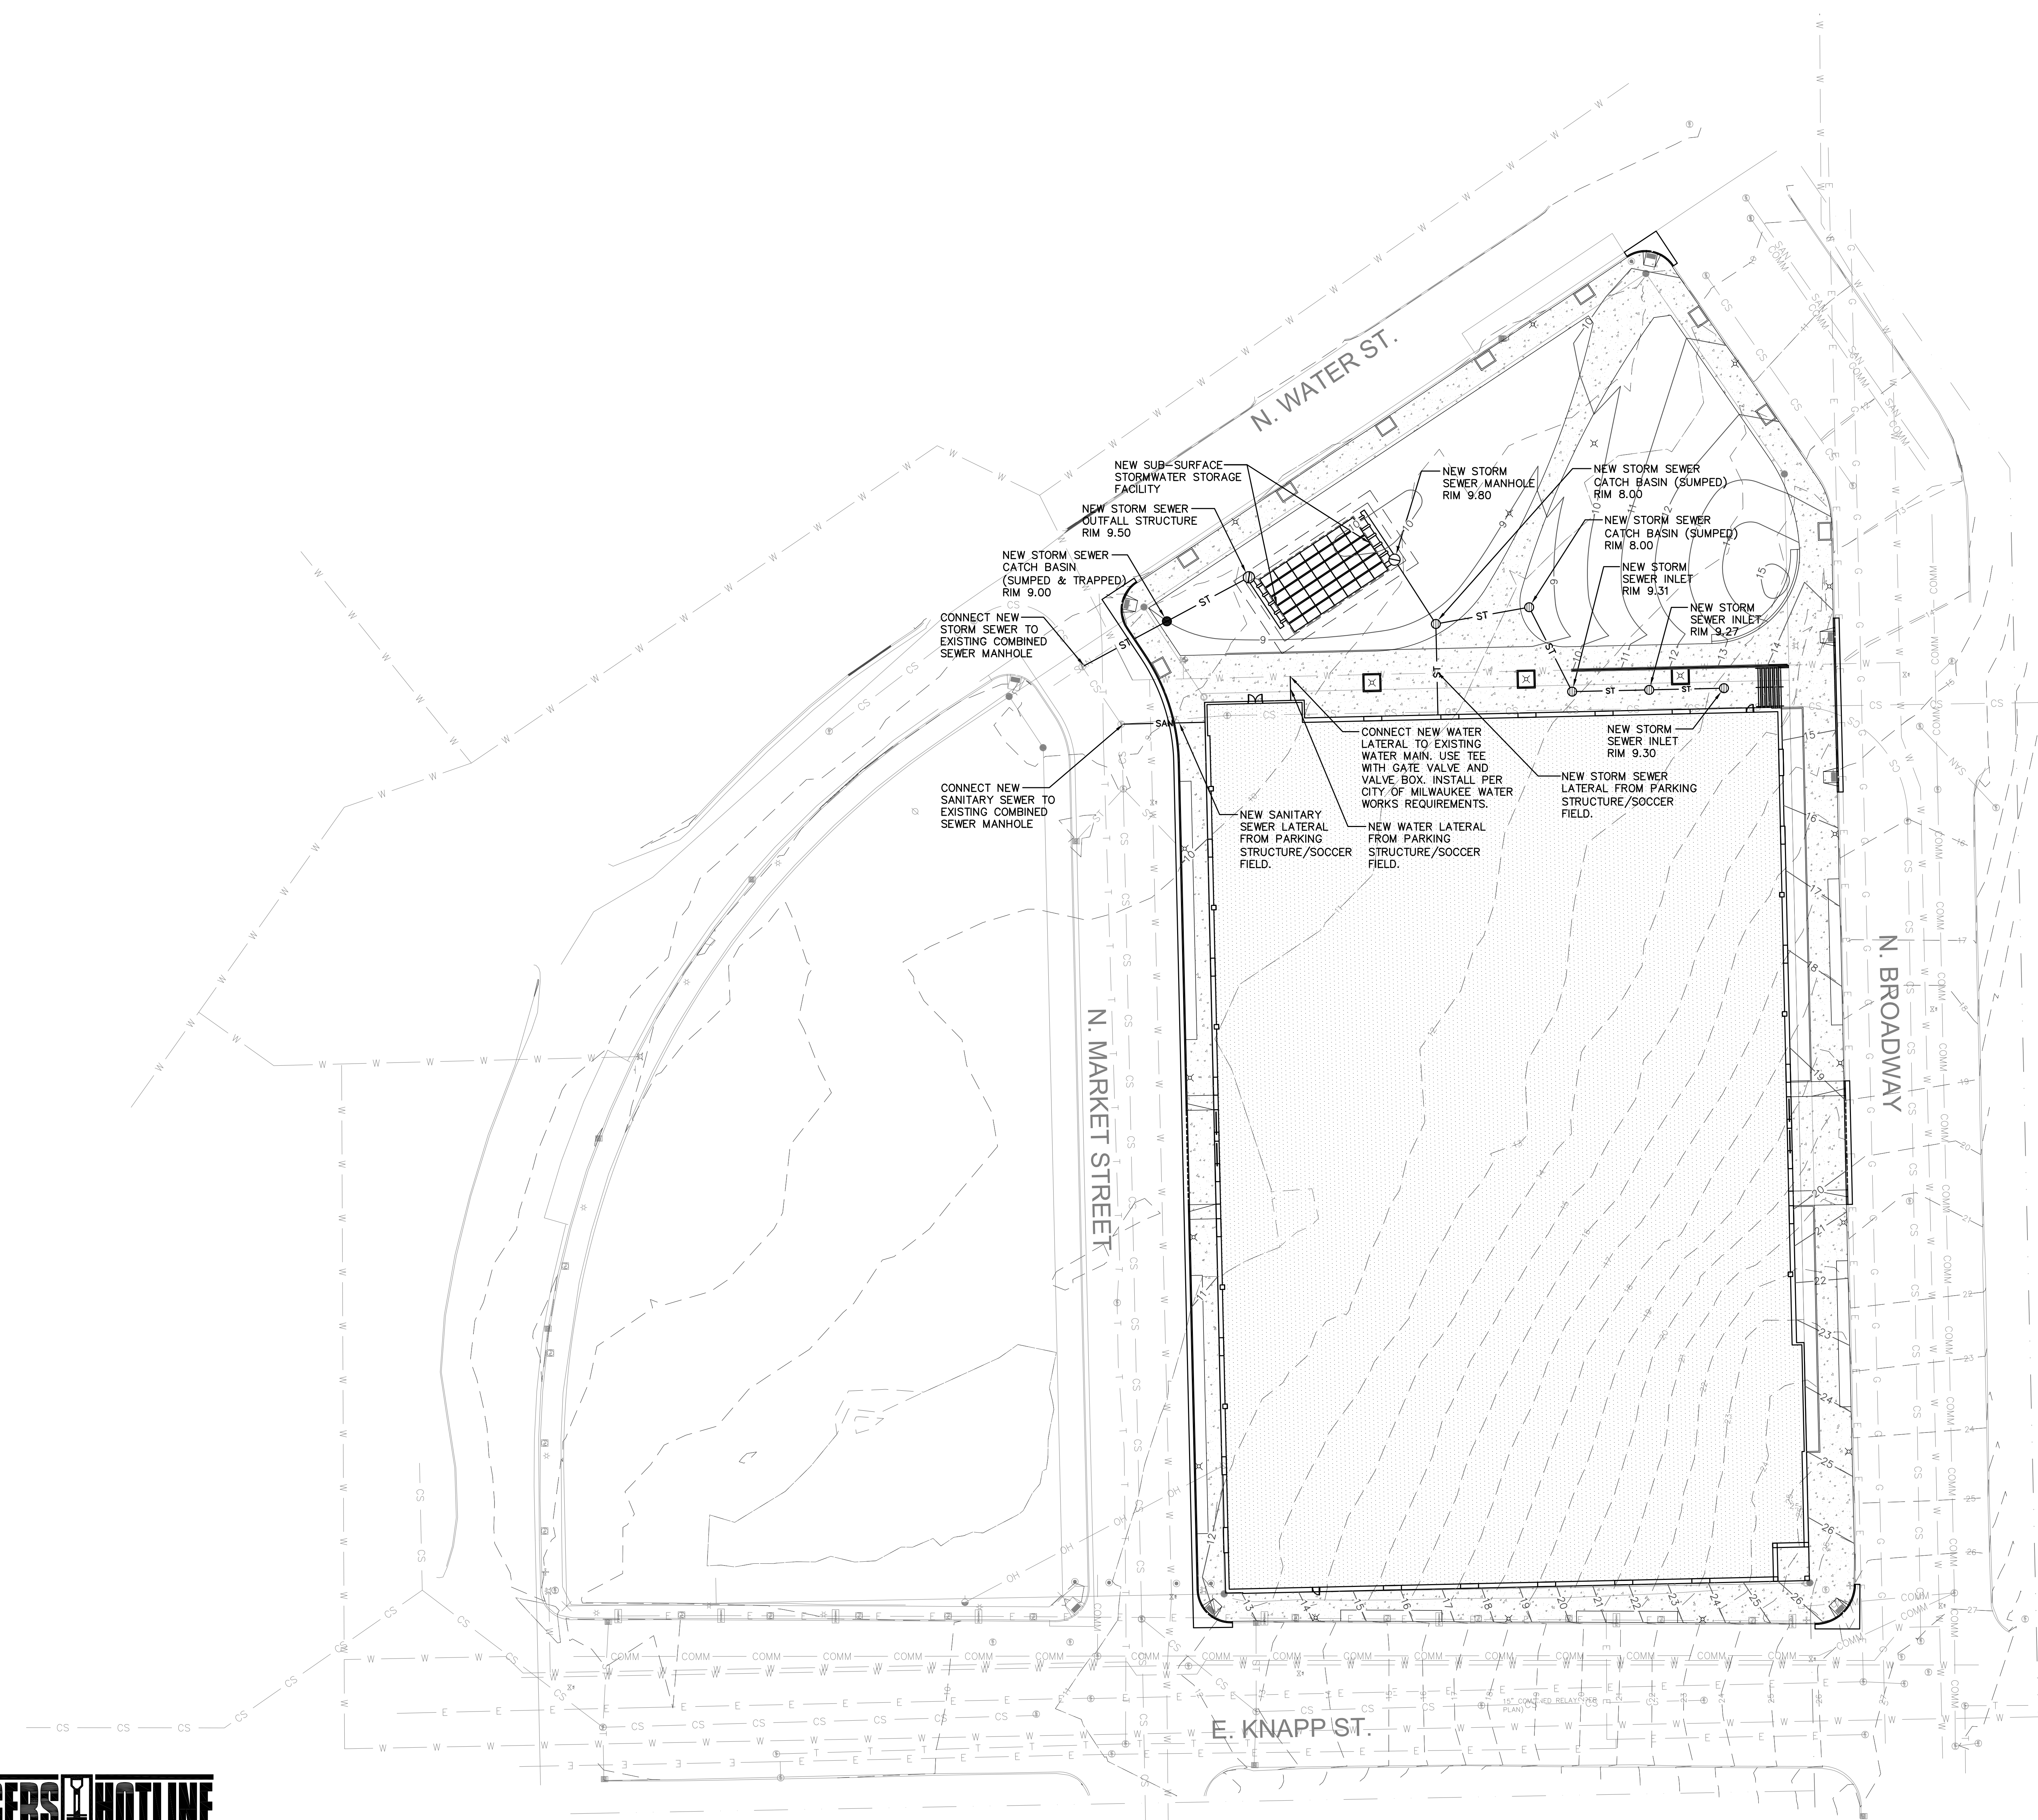

DIGGERSHOTLINE
Toll Free (800) 242-8511
Milwaukee Area (414) 259-1181
Hearing Impaired TDD (800) 542-2289
www.DiggersHotline.com



**UIHLEIN
WILSON**
ARCHITECTS

322 East Michigan Street
Milwaukee, WI 53202

telephone | 414.271.8899
facsimile | 414.271.8942
email | office@uihlein-wilson.com

© UIHLEIN WILSON ARCHITECTS, INC. ALL RIGHTS RESERVED

OWNERSHIP OF DOCUMENTS
This document, and the ideas and designs incorporated herein, are the property of Uihlein Wilson Architects, Inc., and it is not to be used in whole or in part for any other project or purpose without the expressed written authorization of Uihlein Wilson Architects, Inc.

REVISIONS		
NO.	DATE	ISSUE

PROJECT



Proposed MSOE
SOCCER & PARKING
FACILITY

SHEET

SITE UTILITY PLAN

DATE
May 09, 2011
PROJECT NO.
09-117
SHEET NO.



UHLERIN
WILSON
ARCHITECTS

322 East Michigan Street
Milwaukee, WI 53202

telephone | 414.271.8899
facsimile | 414.271.8942
email | office@uhlein-wilson.com

OWNERSHIP OF DOCUMENTS
This document, and the ideas and designs incorporated herein, as an instrument of professional service, is the sole property of Uhllein Wilson Architects, Inc., and is not to be used in whole or in part for any other project or purpose without the expressed written authorization of Uhllein Wilson Architects, Inc.

REVISIONS

NO.	DATE	ISSUE
-----	------	-------

DATE _____
ISSUE _____

(=)

PROJECT



Proposed MSOE SOCCER & PARKING FACILITY

SHEET

LIGHTING

DATE _____

May 09, 2013

PROJECT NO.

09-117

SHEET NO


EAST/WEST SECTION

 $1/16'' = 1^{st}.0$

E-100





SITE LOCATION	$t^a = 30.0^\circ$
	1

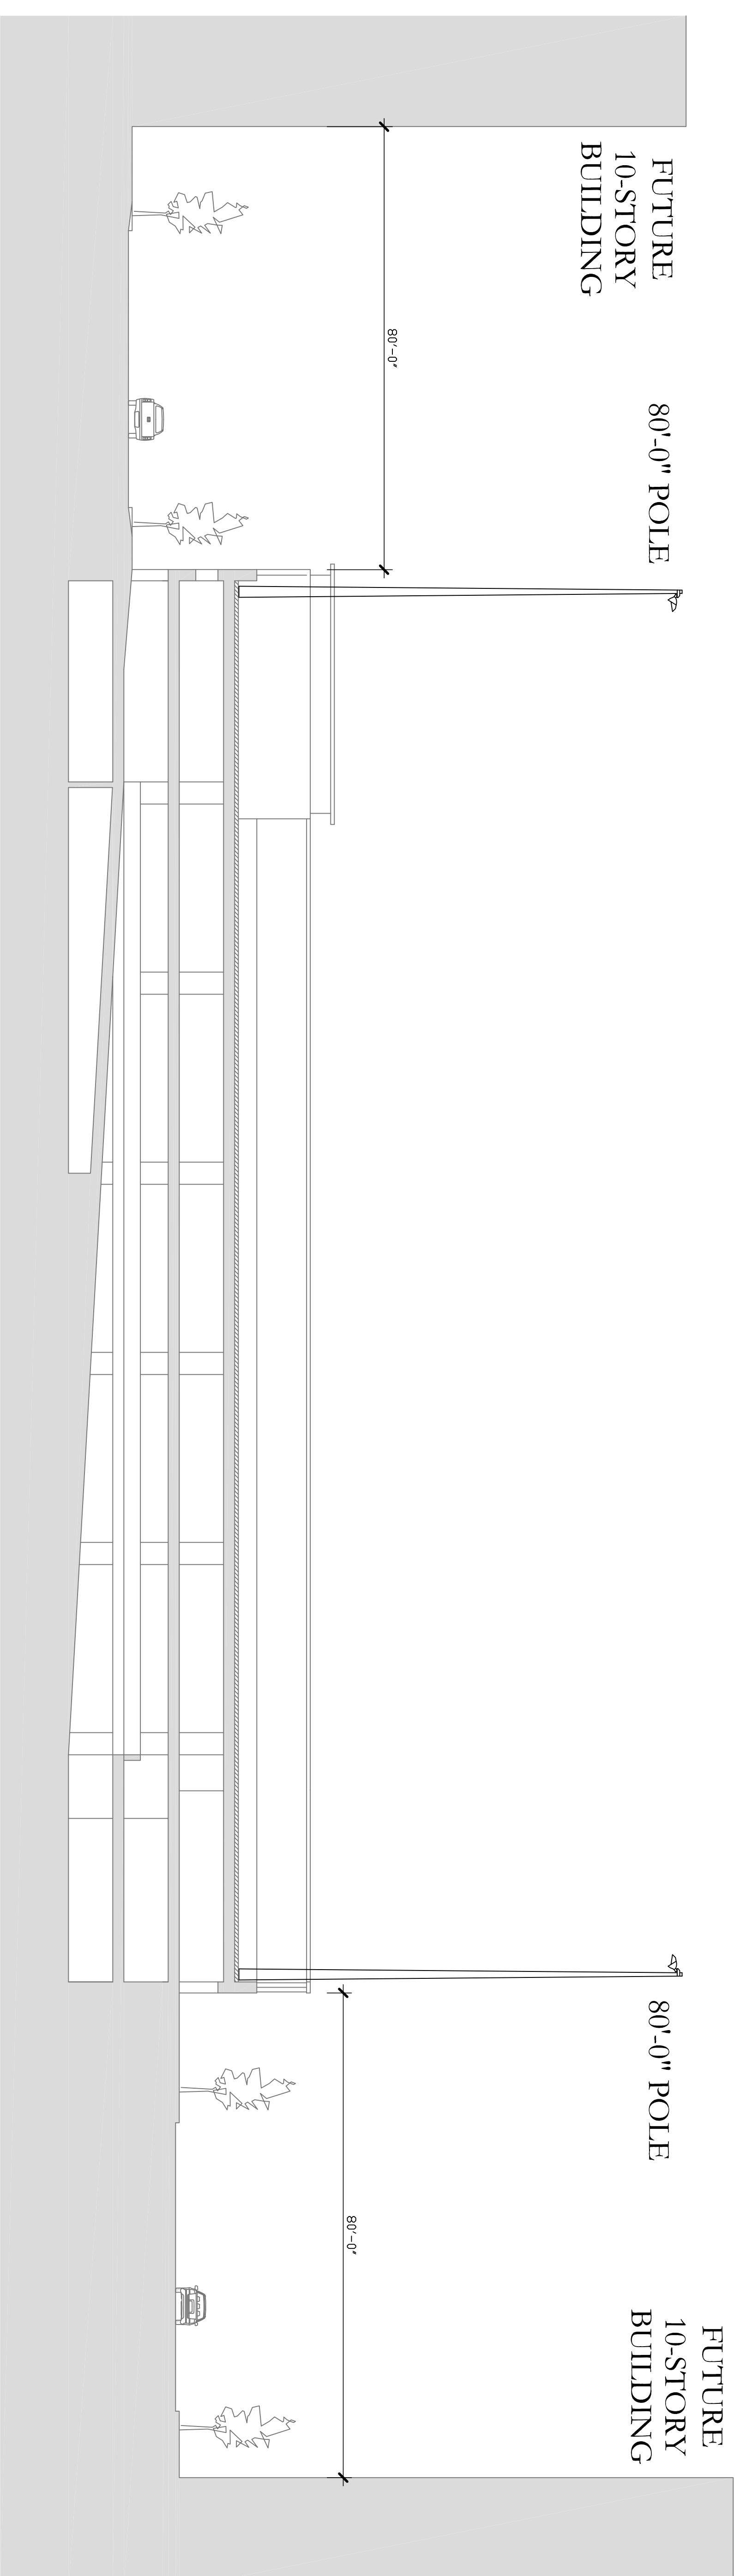

FUTURE BUILDING ELEVATION - EAST	3
1" = 30'-0"	3

FUTURE BUILDING ELEVATION - WEST	4
	4

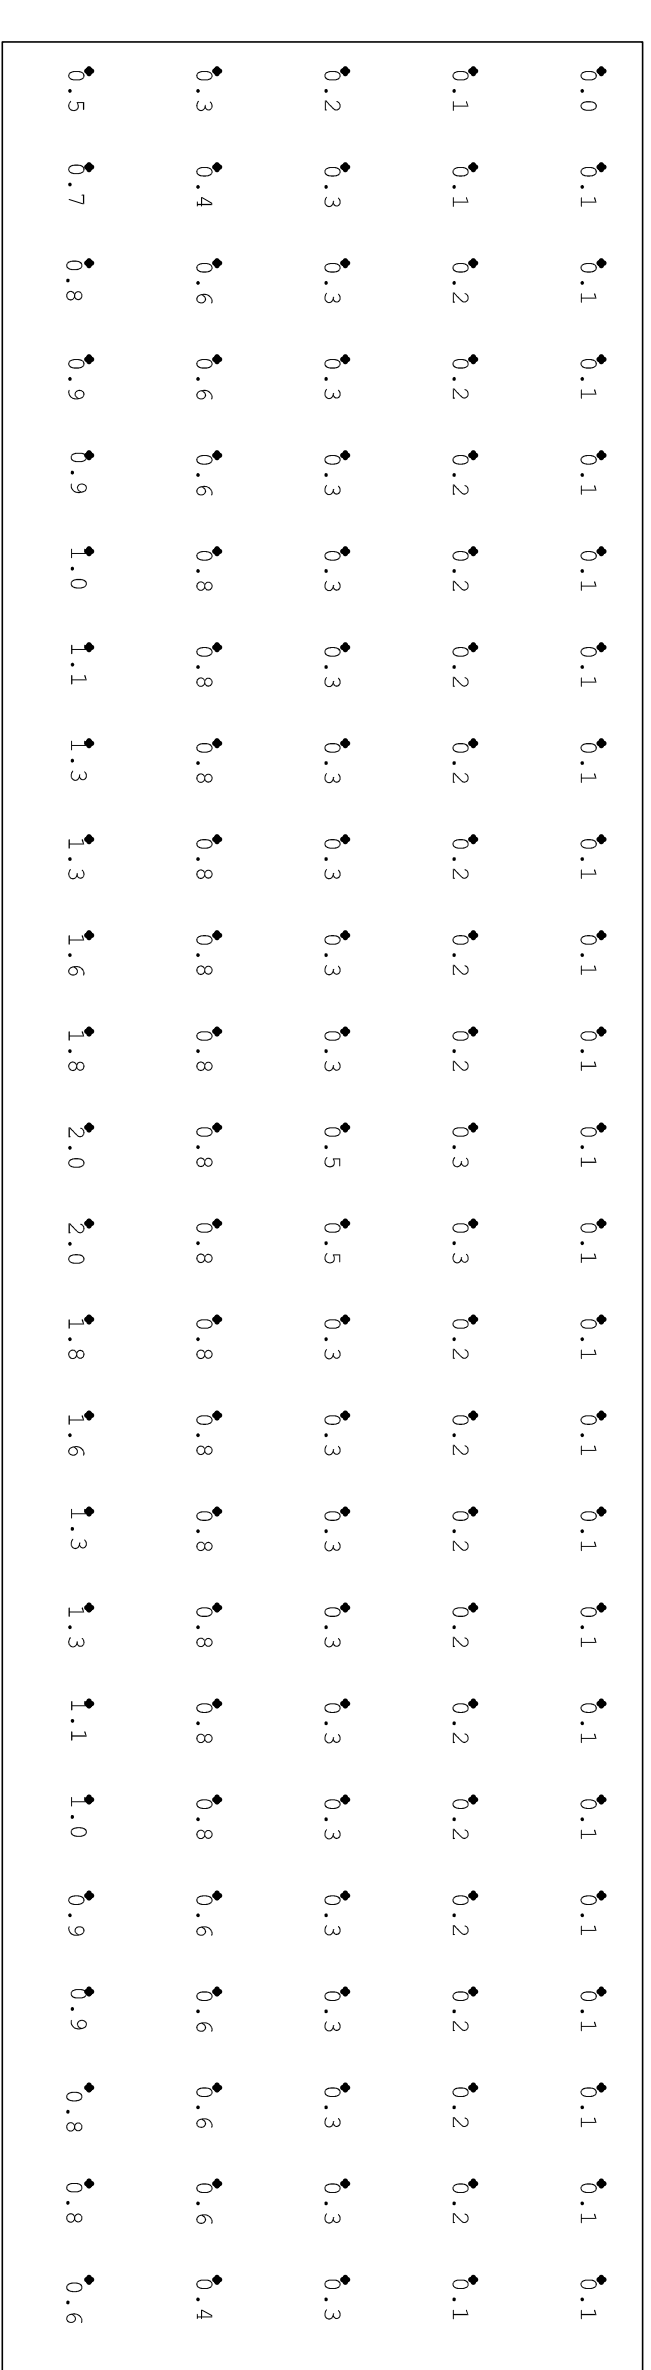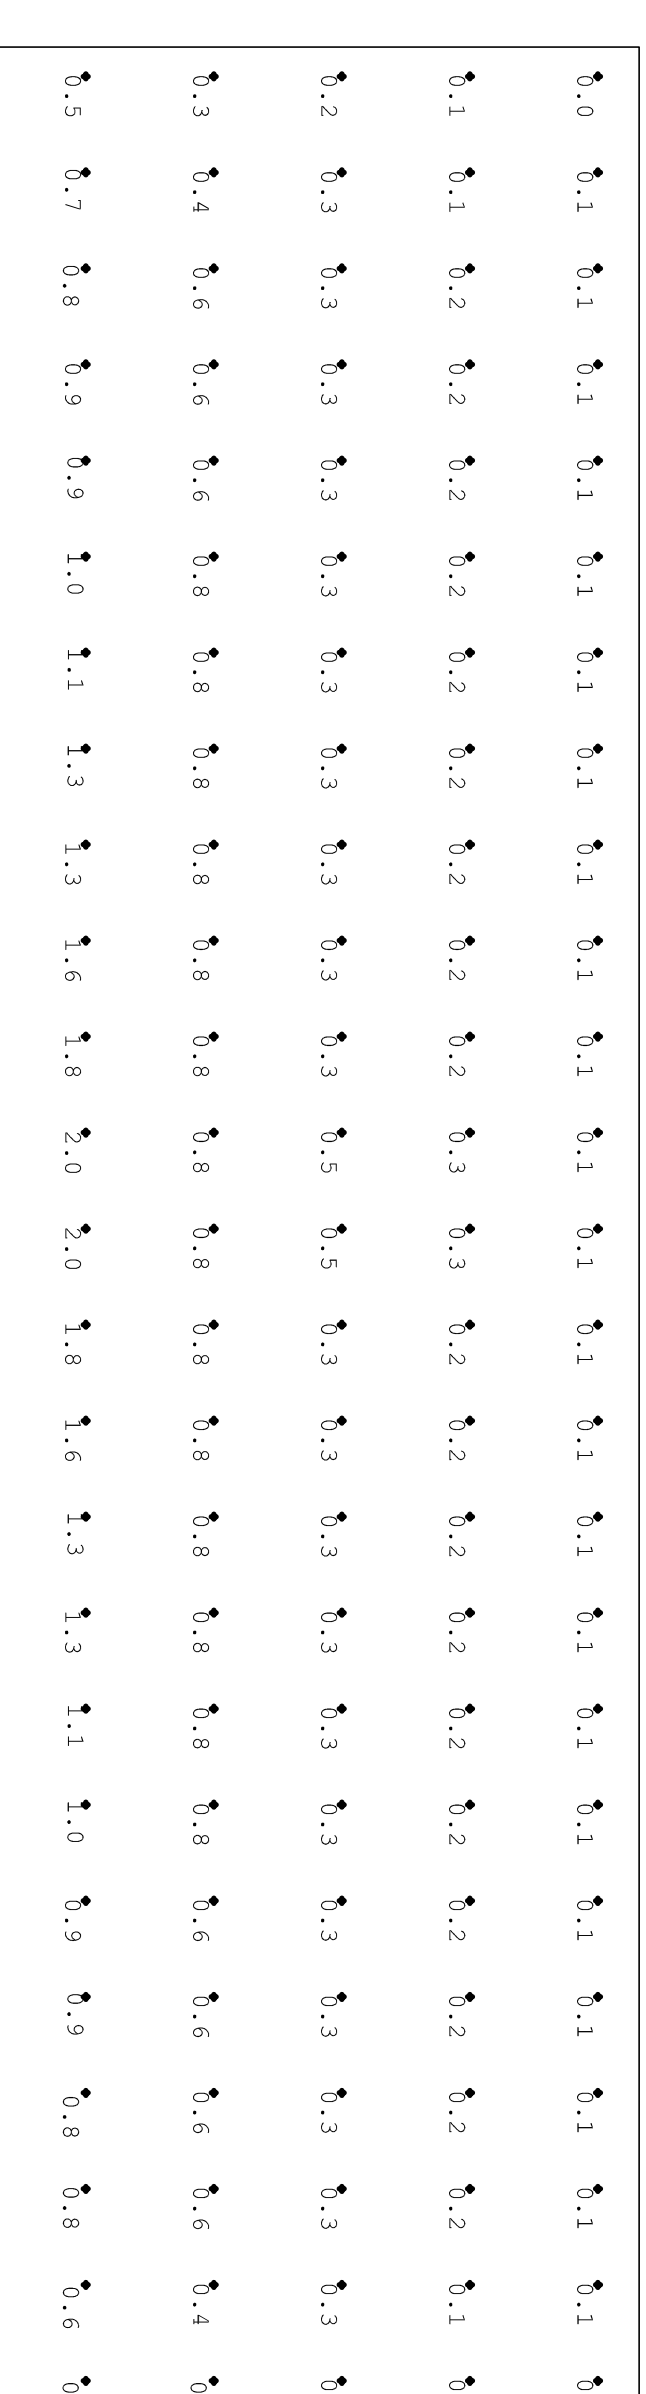

FUTURE BUILDING ELEVATION - EAST	3
1" = 30'-0"	3



**UHLEIN
WILSON**
ARCHITECTS

322 East Michigan Street
Milwaukee, WI 53202
telephone | 414.271.8899
facsimile | 414.271.8942
email | office@uhllein-wilson.com

© UHLEIN WILSON ARCHITECTS, INC. ALL RIGHTS RESERVED.
THIS DRAWING IS THE PROPERTY OF UHLEIN WILSON ARCHITECTS, INC. AND IS TO BE USED ONLY FOR THE PROJECT AND SITE SPECIFICALLY IDENTIFIED HEREON. IT IS NOT TO BE REPRODUCED, COPIED, OR TRANSMITTED IN ANY FORM OR BY ANY MEANS, ELECTRONIC OR MECHANICAL, INCLUDING PHOTOCOPYING, RECORDING, OR BY ANY INFORMATION STORAGE AND RETRIEVAL SYSTEM, WITHOUT THE WRITTEN PERMISSION OF UHLEIN WILSON ARCHITECTS, INC.

REVISIONS			
NO.	DATE	ISSUE	



Proposed MSOE
SOCCER & PARKING
FACILITY

SHEET
FIELD LEVEL
PHOTOMETRICS


DATE
May 09, 2011

PROJECT NO.
09-117

SHEET NO.


E-101

LIGHTING FIXTURE SCHEDULE	
FIXTURE TYPE	DESCRIPTION
TYPE A	FIELD LIGHTS
TYPE B	PARK HARP LIGHTS
TYPE C	CITY STREET LIGHTS

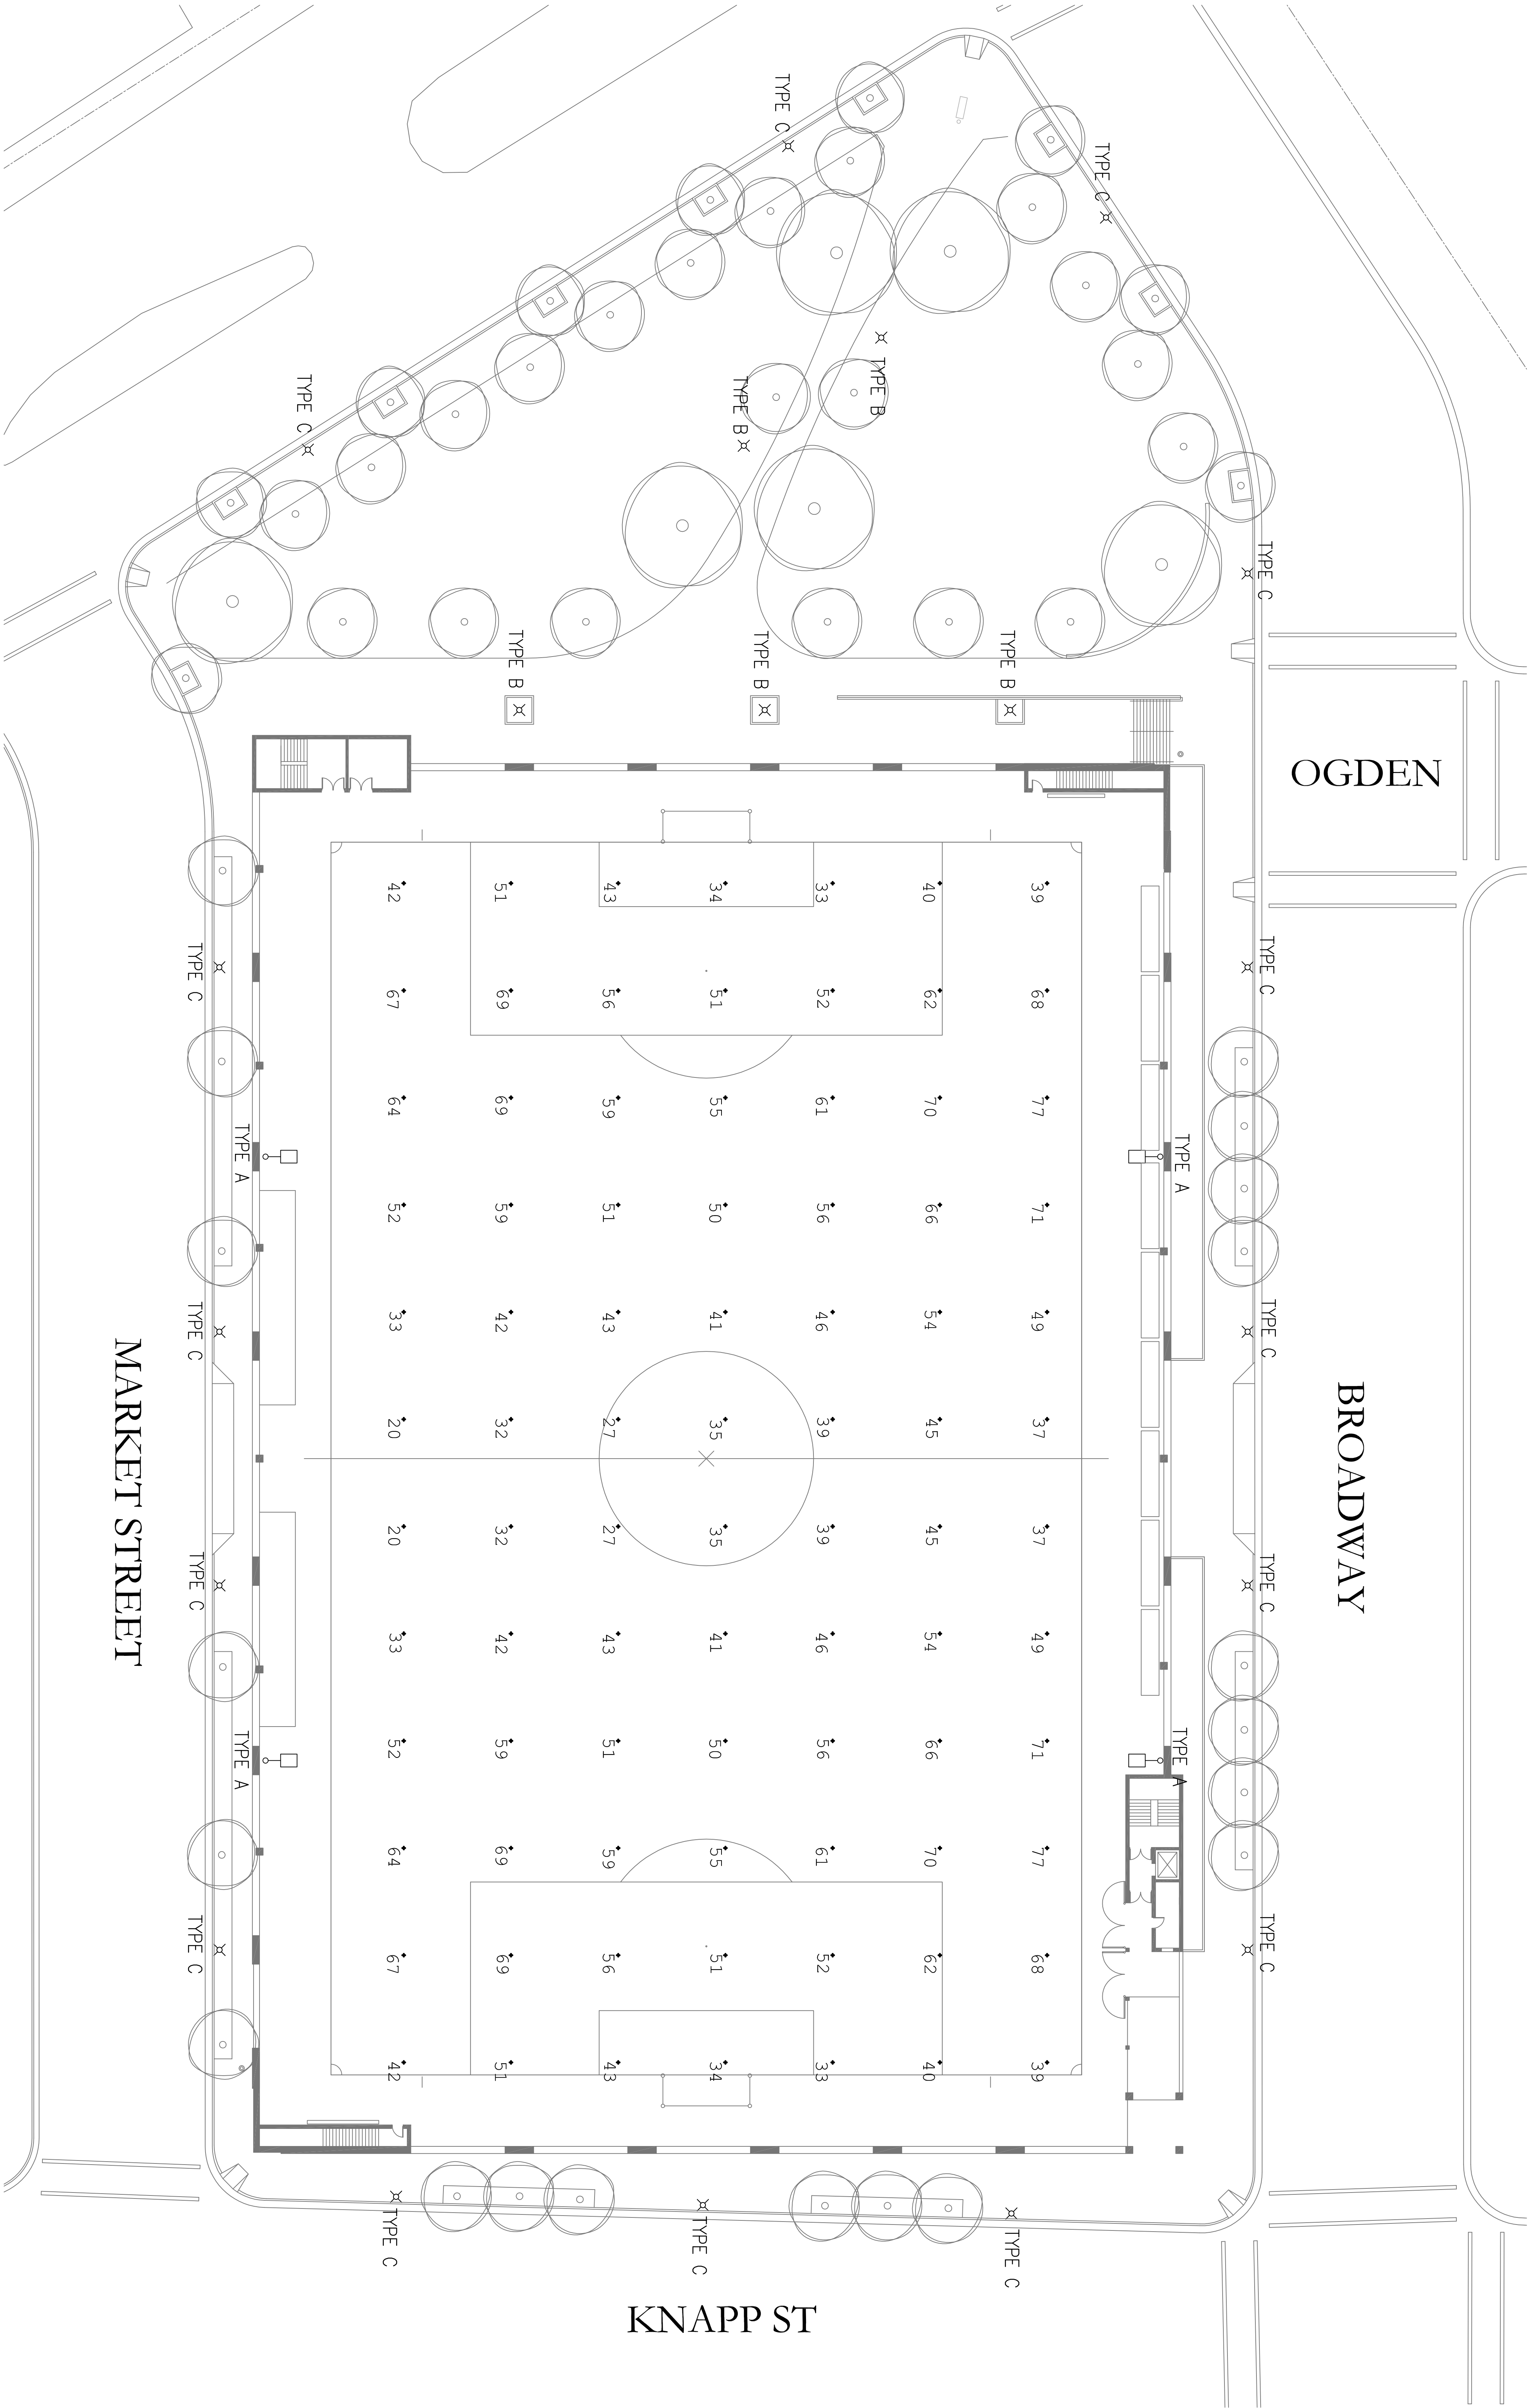

Plant Schedule					
Symbol	Scientific Name	Common Name	Quantity	Spacing	Size
Deciduous Trees					Install
ABP	Pyrus calleryana 'Autumn Blaze'	Autumn Blaze Pear	6	Per Plan	2.5" B&B
ABS	Amelanchier x grandiflora "Autumn Brilliance"	Autumn Brilliance Serviceberry, Multi-stem	4	Per Plan	10' B&B
ACC	Prunus maackii	Amur Chokecherry, Multi-stem	3	Per Plan	10' B&B
AFM	Acer x Freemanii 'Autumn Fantasy'	Autumn Fantasy Maple	6	Per Plan	3" B&B
JTL	Syringa reticulata 'Ivory Silk'	Japanese Tree Lilac Ivory Silk	21	Per Plan	2.5" B&B
KCT	Gymnocladus dioecese	Kentucky Coffee Tree	1	Per Plan	3" B&B
SL	Tilia tomentosa 'Sterling'	Sterling Linden	14	Per Plan	3" B&B
SWO	Quercus bicolor	Swamp White Oak	1	Per Plan	3" B&B
Deciduous Shrubs					
CC	Cotoneaster apiculatus	Cranberry Cotoneaster	12	Per Plan	#2 Cont.
CR	Rosa x 'Champlain'	Champlain Rose	4	Per Plan	#3 Pot
DBH	Diervilla lonicera	Dwarf Bush Honeysuckle	170	Per Plan	#2 Pot
DNB	Physocarpus opulifolius 'Monlo'	Diabolo Ninebark	1	Per Plan	36" B&B
JRW	Weigelia florida 'Java Red'	Java Red Weigelia	12	Per Plan	#3 Pot
RTD	Cornus Sericea	Red Twig Dogwood	17	Per Plan	36" B&B
Perennials					
HDG	Pennisetum alopec. 'Hameln'	Hameln Dwarf Fountain Grass	84	Per Plan	#1 Pot
KFG	Calamagrostis x acutiflora	Karl Foerster Feather Reed Grass	23	Per Plan	#1 Pot
SMG	Miscanthus sinensis 'Silberfeder'	Silberfeder Maiden Grass	12	Per Plan	#1 Pot


NOTE: Installation contractor is responsible for verifying plant count from plan. Plan quantities take precedence over list.

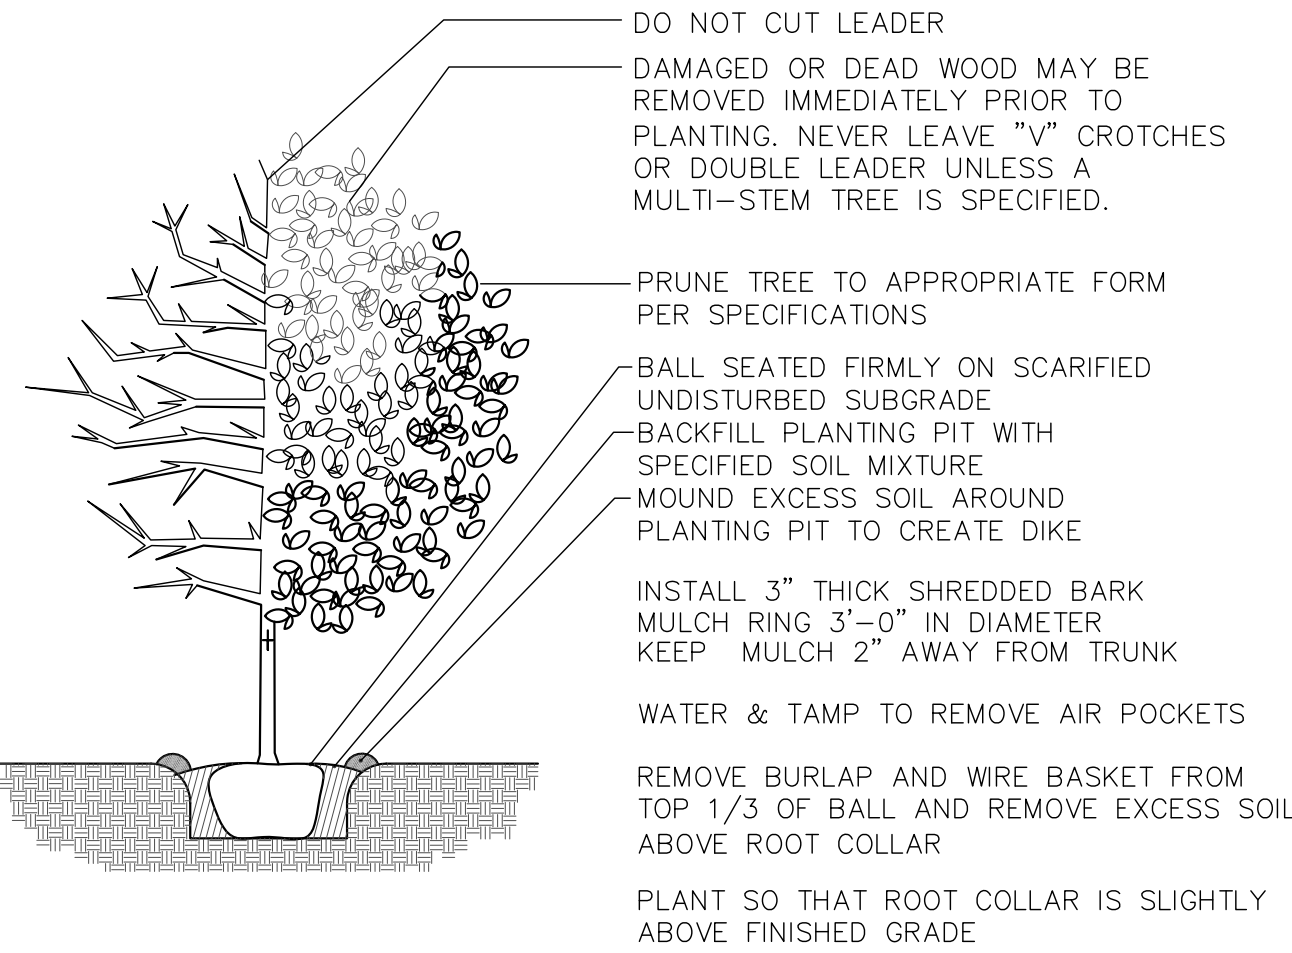


1 DECIDUOUS TREE PLANTING
N.T.S.

- TREE PLANTING NOTES
1. STAKING — ONLY TREES THAT ARE UNABLE TO REMAIN UPRIGHT AFTER PLANTING SHALL BE STAKED. TREES WILL BECOME STRONGER FASTER WHEN THE TOP 2/3 OF THE TREE IS FREE TO SWAY. TIE WEBBED STRAPPING TO THE TREE 1/3 UP THE TRUNK AND WIRE TO THREE STAKES POSITIONED EVENLY AROUND THE TREE. STAKES SHOULD BE DRIVEN DEEPLY INTO THE GROUND TO PREVENT DISLODGING. CHECK AT LEAST EVERY THREE MONTHS FOR BINDING OR OTHER PROBLEMS. STAKES AND TIES SHOULD BE REMOVED SIX MONTHS TO ONE YEAR AFTER PLANTING.
 2. PRUNING — CLEANLY PRUNE DAMAGED BRANCHES AND ROOTS AT THIS TIME. ADDITIONAL PRUNING SHOULD BE ONLY FOR SHAPING PURPOSES.
 3. PLANTING — ALL SYNTHETIC MATERIAL SHOULD BE REMOVED FROM THE ROOTS, TRUNK, OR CROWN OF PLANT. SET THE PLANT SO IT WILL BE AT ITS ORIGINAL DEPTH SLIGHTLY ABOVE EXISTING GRADE. BACKFILL WITH SPECIFIED SOIL MIX.
 4. WATERING — THE BACKFILL AND ROOTS OF ALL NEWLY SET PLANT MATERIAL SHOULD BE WATERED AS BACKFILLING IS DONE SO THE SOIL AND ROOTS ARE THOROUGHLY SOAKED.



2 GENERAL PLANTING NOTES
N.T.S.

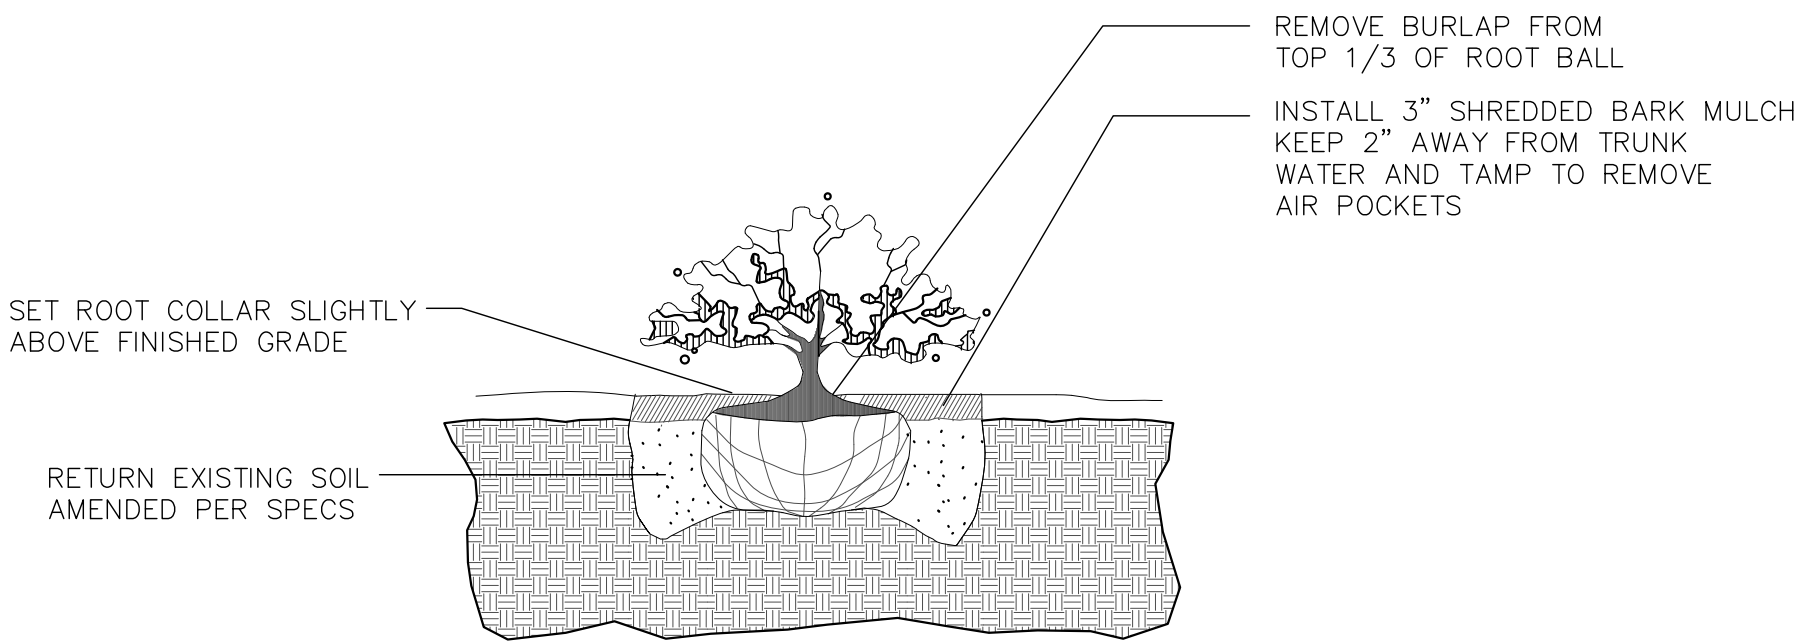

3 DECIDUOUS & EVERGREEN SHRUB PLANTING
N.T.S.

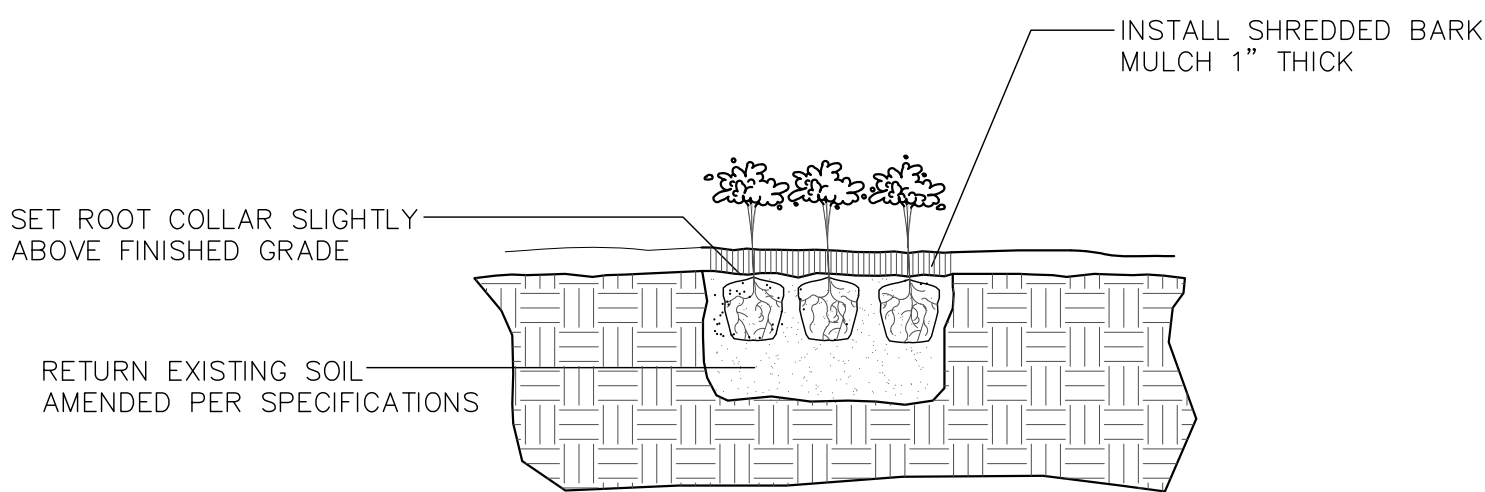

4 PERENNIAL PLANTING
N.T.S.

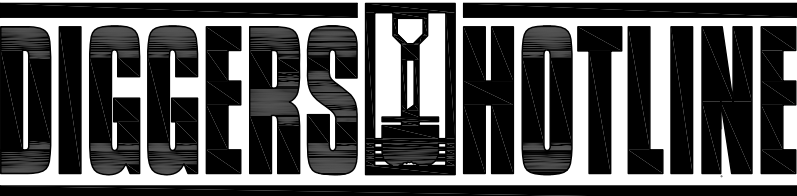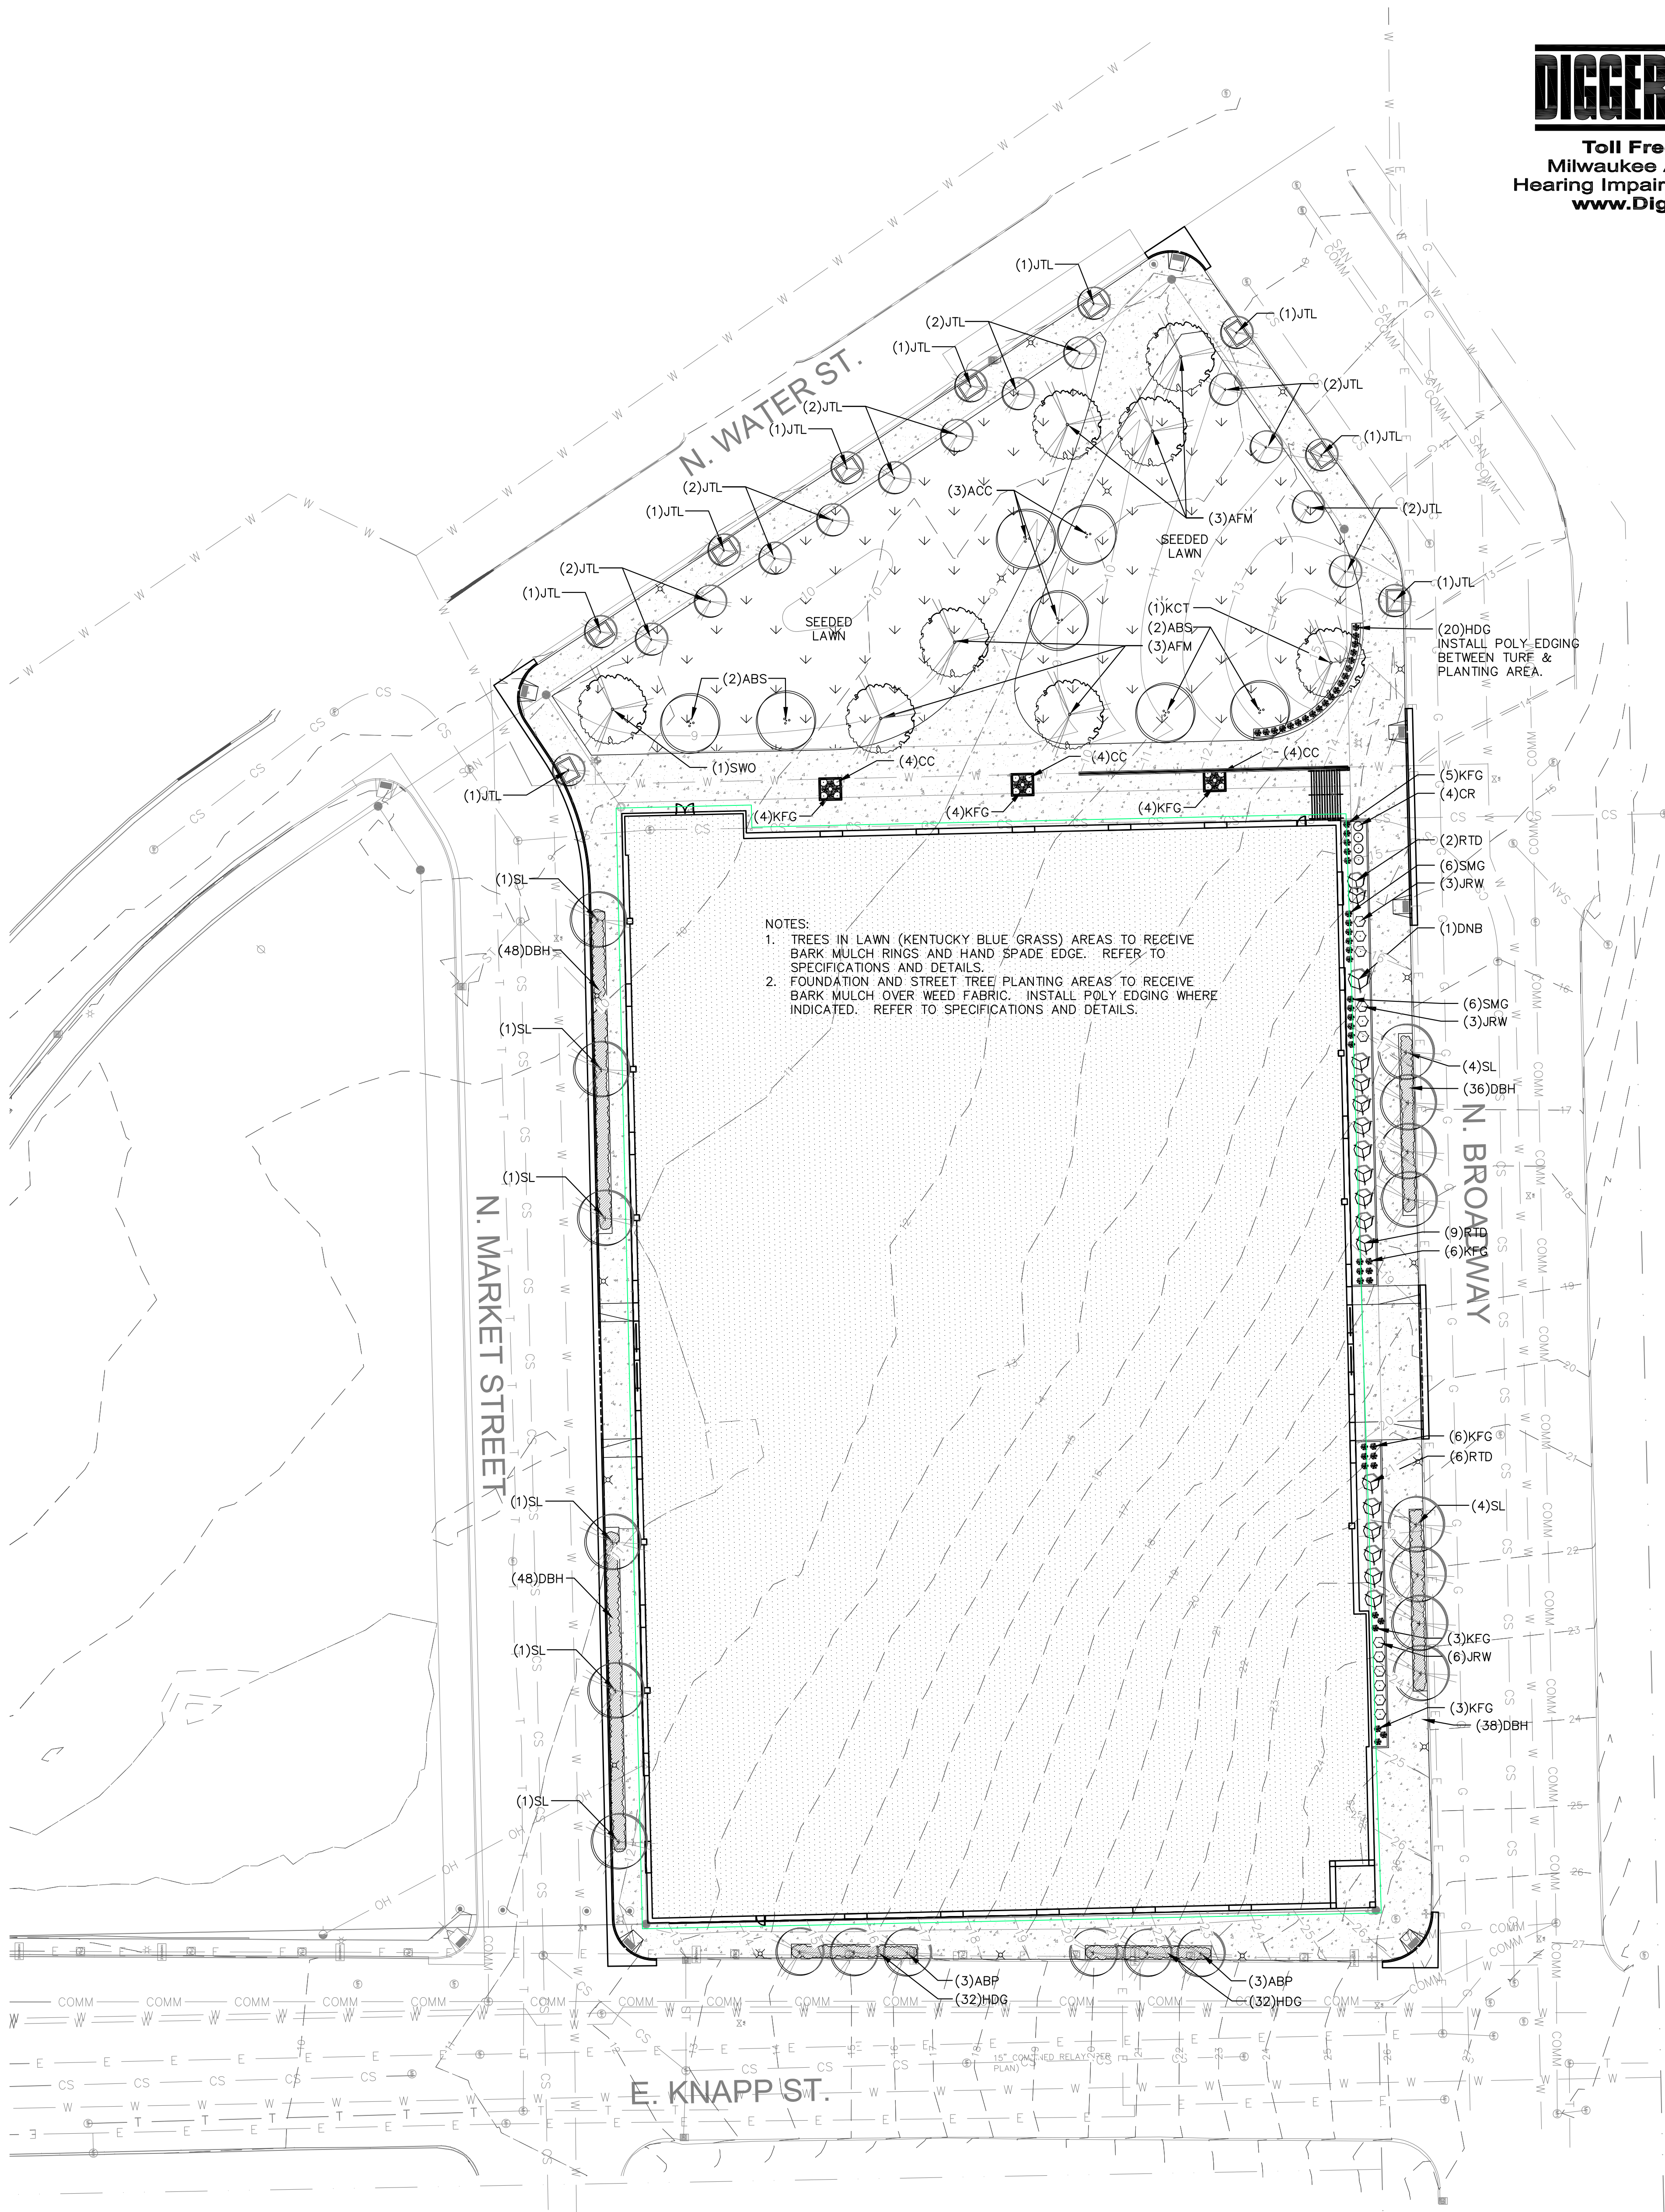

Toll Free (800) 242-8511
Milwaukee Area (414) 259-1181
Hearing Impaired TDD (800) 542-2289
www.DiggersHotline.com



UIHLEIN
WILSON
ARCHITECTS

322 East Michigan Street
Milwaukee, WI 53202

telephone | 414.271.8899
facsimile | 414.271.8942
email | office@uihlein-wilson.com

© UIHLEIN WILSON ARCHITECTS, INC. ALL RIGHTS RESERVED

OWNERSHIP OF DOCUMENTS
This document, and the ideas and designs incorporated herein, are the property of Uihlein Wilson Architects, Inc., and it is not to be used in whole or in part for any other project or purpose without the expressed written authorization of Uihlein Wilson Architects, Inc.

REVISIONS

NO. DATE ISSUE

PROJECT



Proposed MSOE
SOCCER & PARKING
FACILITY

SHEET

LANDSCAPE PLAN

DATE

May 09, 2011

PROJECT NO.

09-117

SHEET NO.



1" = 30'-0"

1



**UHLEIN
WILSON**
ARCHITECTS

322 East Michigan Street
Milwaukee, WI 53202
telephone | 414.271.8899
facsimile | 414.271.8942
email | office@uhllein-wilson.com

© UHLEIN WILSON ARCHITECTS, INC. ALL RIGHTS RESERVED
THIS SHEET IS THE PROPERTY OF UHLEIN WILSON ARCHITECTS, INC. IT IS TO BE USED ONLY FOR THE PROJECT AND SITE SPECIFICALLY IDENTIFIED HEREON. IT IS NOT TO BE REPRODUCED, COPIED, OR TRANSMITTED IN ANY FORM OR BY ANY MEANS, ELECTRONIC OR MECHANICAL, INCLUDING PHOTOCOPYING, RECORDING, OR BY ANY INFORMATION STORAGE AND RETRIEVAL SYSTEM, WITHOUT THE WRITTEN PERMISSION OF UHLEIN WILSON ARCHITECTS, INC.

REVISIONS			
NO.	DATE	ISSUE	



Proposed MSOE
SOCCER & PARKING
FACILITY

SHEET

LOWER LEVEL
PLAN

DATE


May 9, 2011

PROJECT NO.

09-117

SHEET NO.

PROJECT

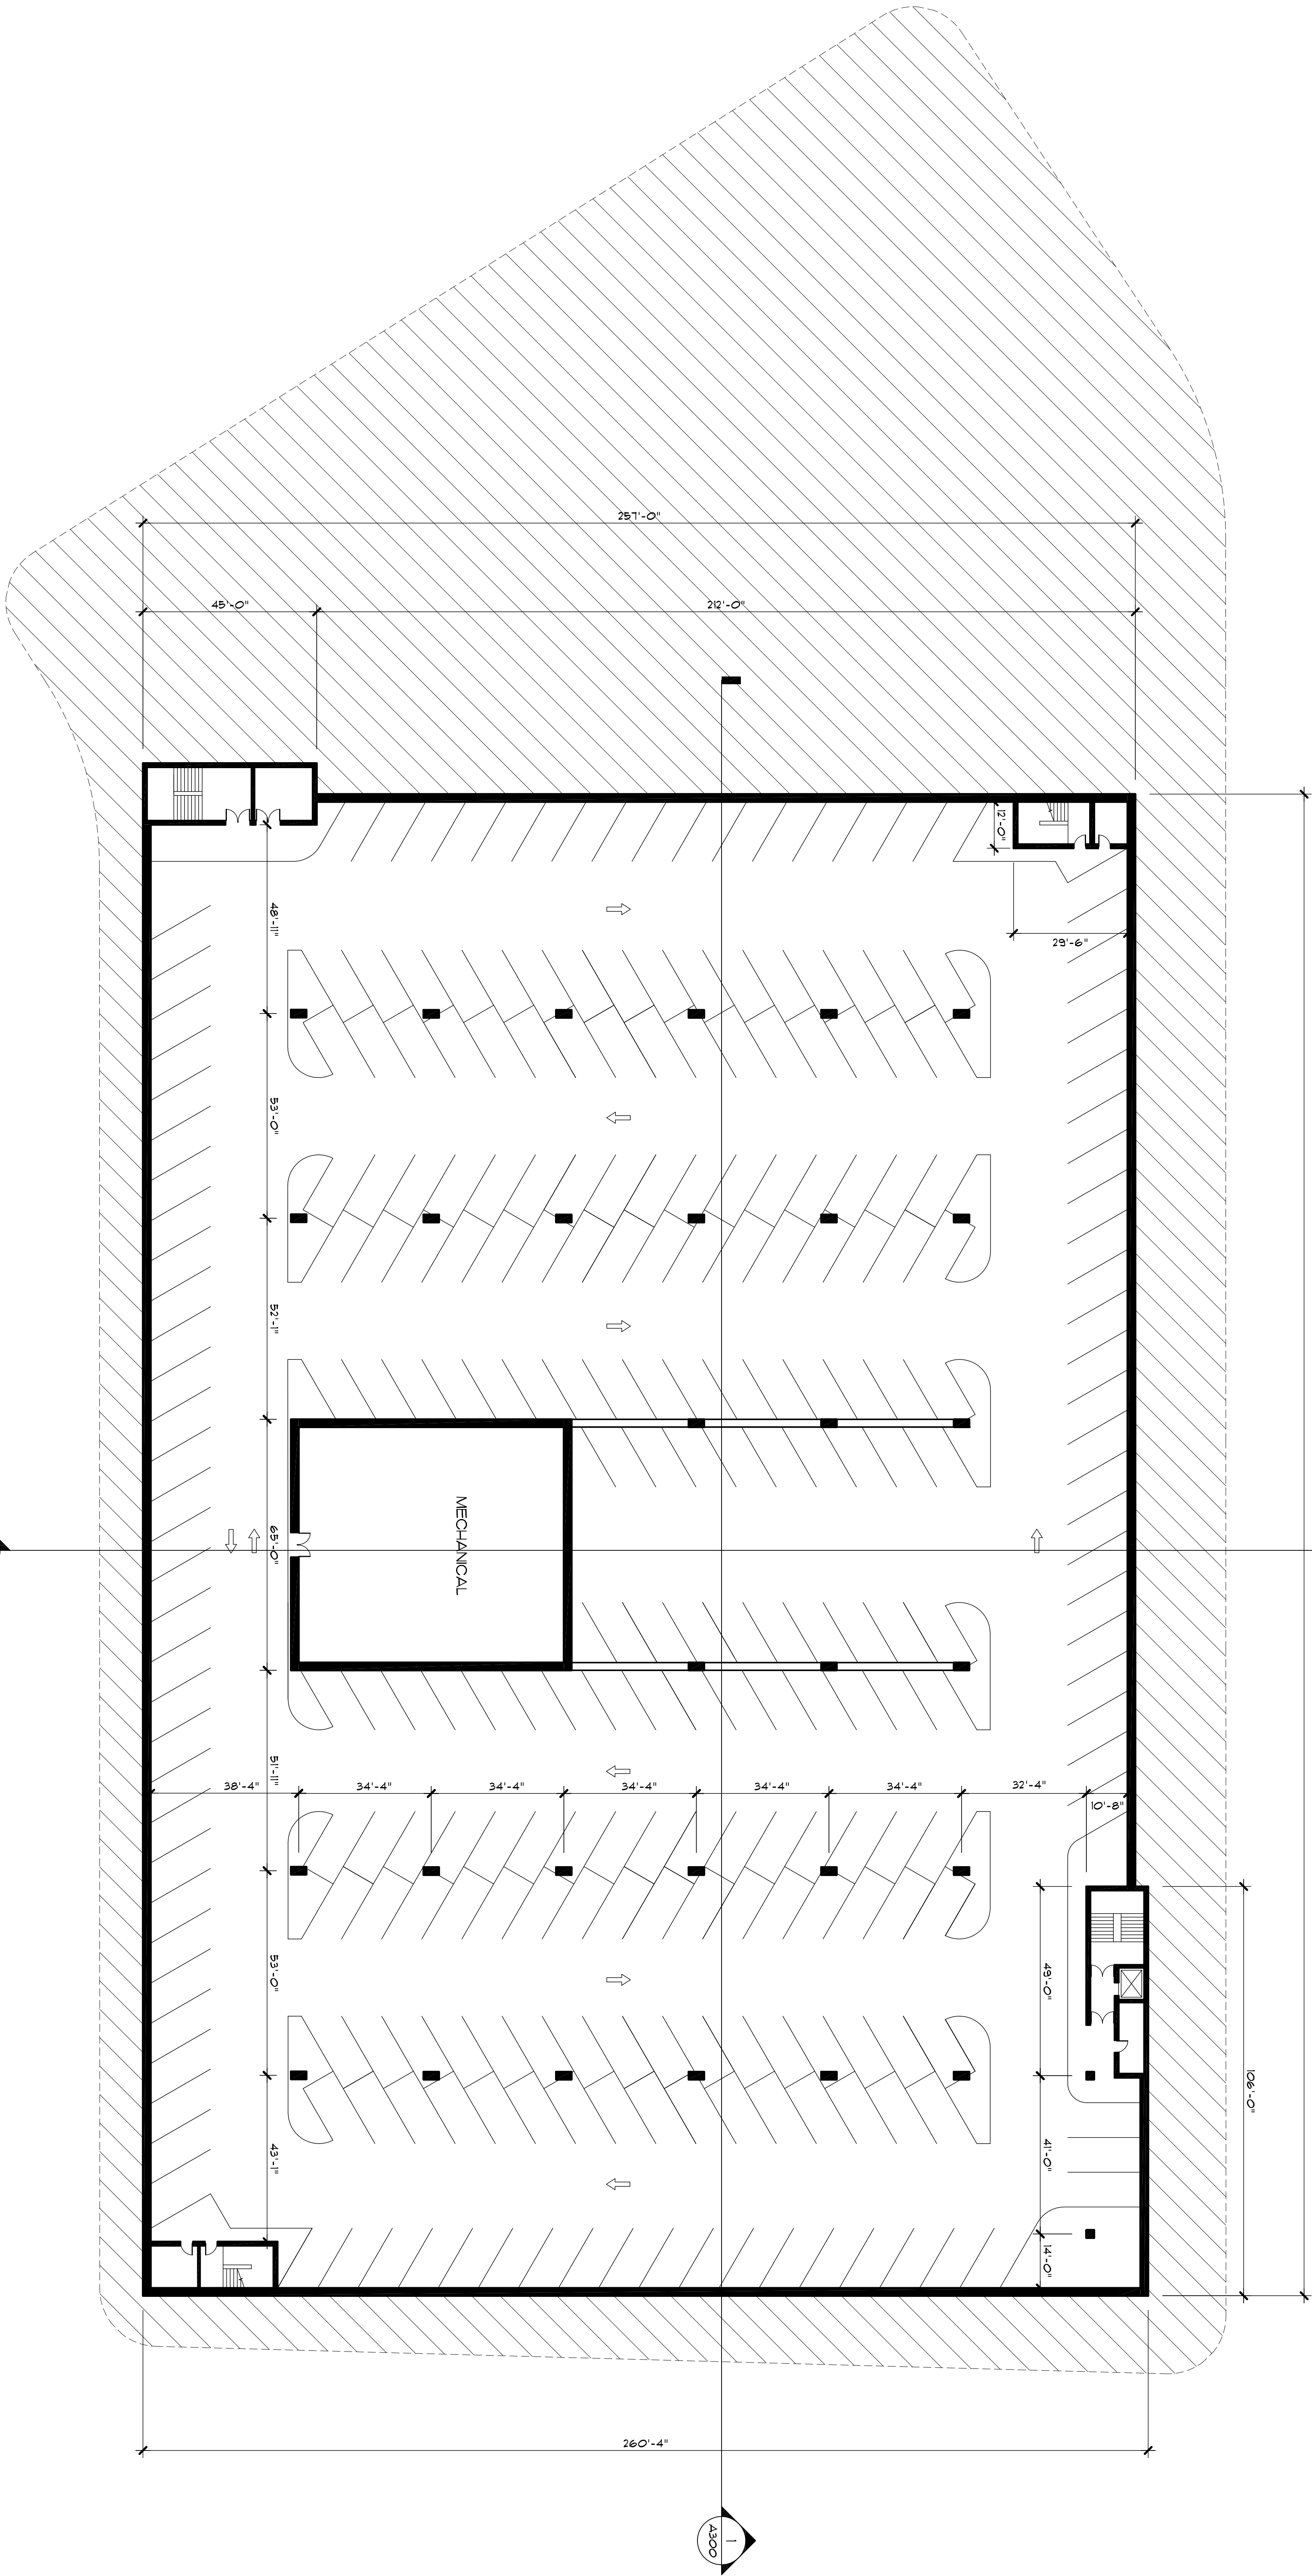



**UHLEIN
WILSON**
ARCHITECTS

322 East Michigan Street
Milwaukee, WI 53202

telephone | 414.271.8899
facsimile | 414.271.8942
email | office@uhllein-wilson.com

© UHLEIN WILSON ARCHITECTS, INC. ALL RIGHTS RESERVED.
THIS SHEET IS THE PROPERTY OF UHLEIN WILSON ARCHITECTS, INC. IT IS TO BE USED ONLY FOR THE PROJECT AND SITE SPECIFICALLY IDENTIFIED HEREON. IT IS NOT TO BE REPRODUCED, COPIED, OR TRANSMITTED IN ANY FORM OR BY ANY MEANS, ELECTRONIC OR MECHANICAL, INCLUDING PHOTOCOPYING, RECORDING, OR BY ANY INFORMATION STORAGE AND RETRIEVAL SYSTEM, WITHOUT THE WRITTEN PERMISSION OF UHLEIN WILSON ARCHITECTS, INC.

REVISIONS			
NO.	DATE	ISSUE	



Proposed MSOE
SOCCER & PARKING
FACILITY

SHEET

MARKET LEVEL
PLAN

DATE
May 9, 2011

PROJECT NO.
09-117

SHEET NO.





**UHLEIN
WILSON**
ARCHITECTS

322 East Michigan Street
Milwaukee, WI 53202

telephone | 414.271.8899
facsimile | 414.271.8942
email | office@uhllein-wilson.com

© UHLEIN WILSON ARCHITECTS, INC. ALL RIGHTS RESERVED
THIS SHEET IS THE PROPERTY OF UHLEIN WILSON ARCHITECTS, INC. AND IS TO BE USED ONLY FOR THE PROJECT AND SITE SPECIFICALLY IDENTIFIED HEREON. IT IS TO BE KEPT IN THE OFFICE OF THE ARCHITECT AND IS NOT TO BE LOANED, REPRODUCED, COPIED, OR IN ANY MANNER USED FOR ANY OTHER PROJECT WITHOUT THE WRITTEN PERMISSION OF UHLEIN WILSON ARCHITECTS, INC.

REVISIONS			
NO.	DATE	ISSUE	

PROJECT



Proposed MSOE
SOCCER & PARKING
FACILITY

SHEET

BROADWAY LEVEL
PLAN

DATE

May 9, 2011

PROJECT NO.

09-117

SHEET NO.



A-102





**UHLEIN
WILSON**
ARCHITECTS

322 East Michigan Street
Milwaukee, WI 53202

telephone | 414.271.8899
facsimile | 414.271.8942
email | office@uhllein-wilson.com

© UHLEIN WILSON ARCHITECTS, INC. ALL RIGHTS RESERVED
THIS SHEET IS THE PROPERTY OF UHLEIN WILSON ARCHITECTS, INC. AND IS NOT TO BE REPRODUCED OR TRANSMITTED IN ANY FORM OR BY ANY MEANS, ELECTRONIC OR MECHANICAL, INCLUDING PHOTOCOPYING, RECORDING, OR BY ANY INFORMATION STORAGE AND RETRIEVAL SYSTEM, WITHOUT THE WRITTEN PERMISSION OF UHLEIN WILSON ARCHITECTS, INC.

REVISIONS			
NO.	DATE	ISSUE	



Proposed MSOE
SOCCER & PARKING
FACILITY

SHEET

FIELD LEVEL
PLAN


DATE
May 9, 2011

PROJECT NO.
09-117

SHEET NO.

A-103



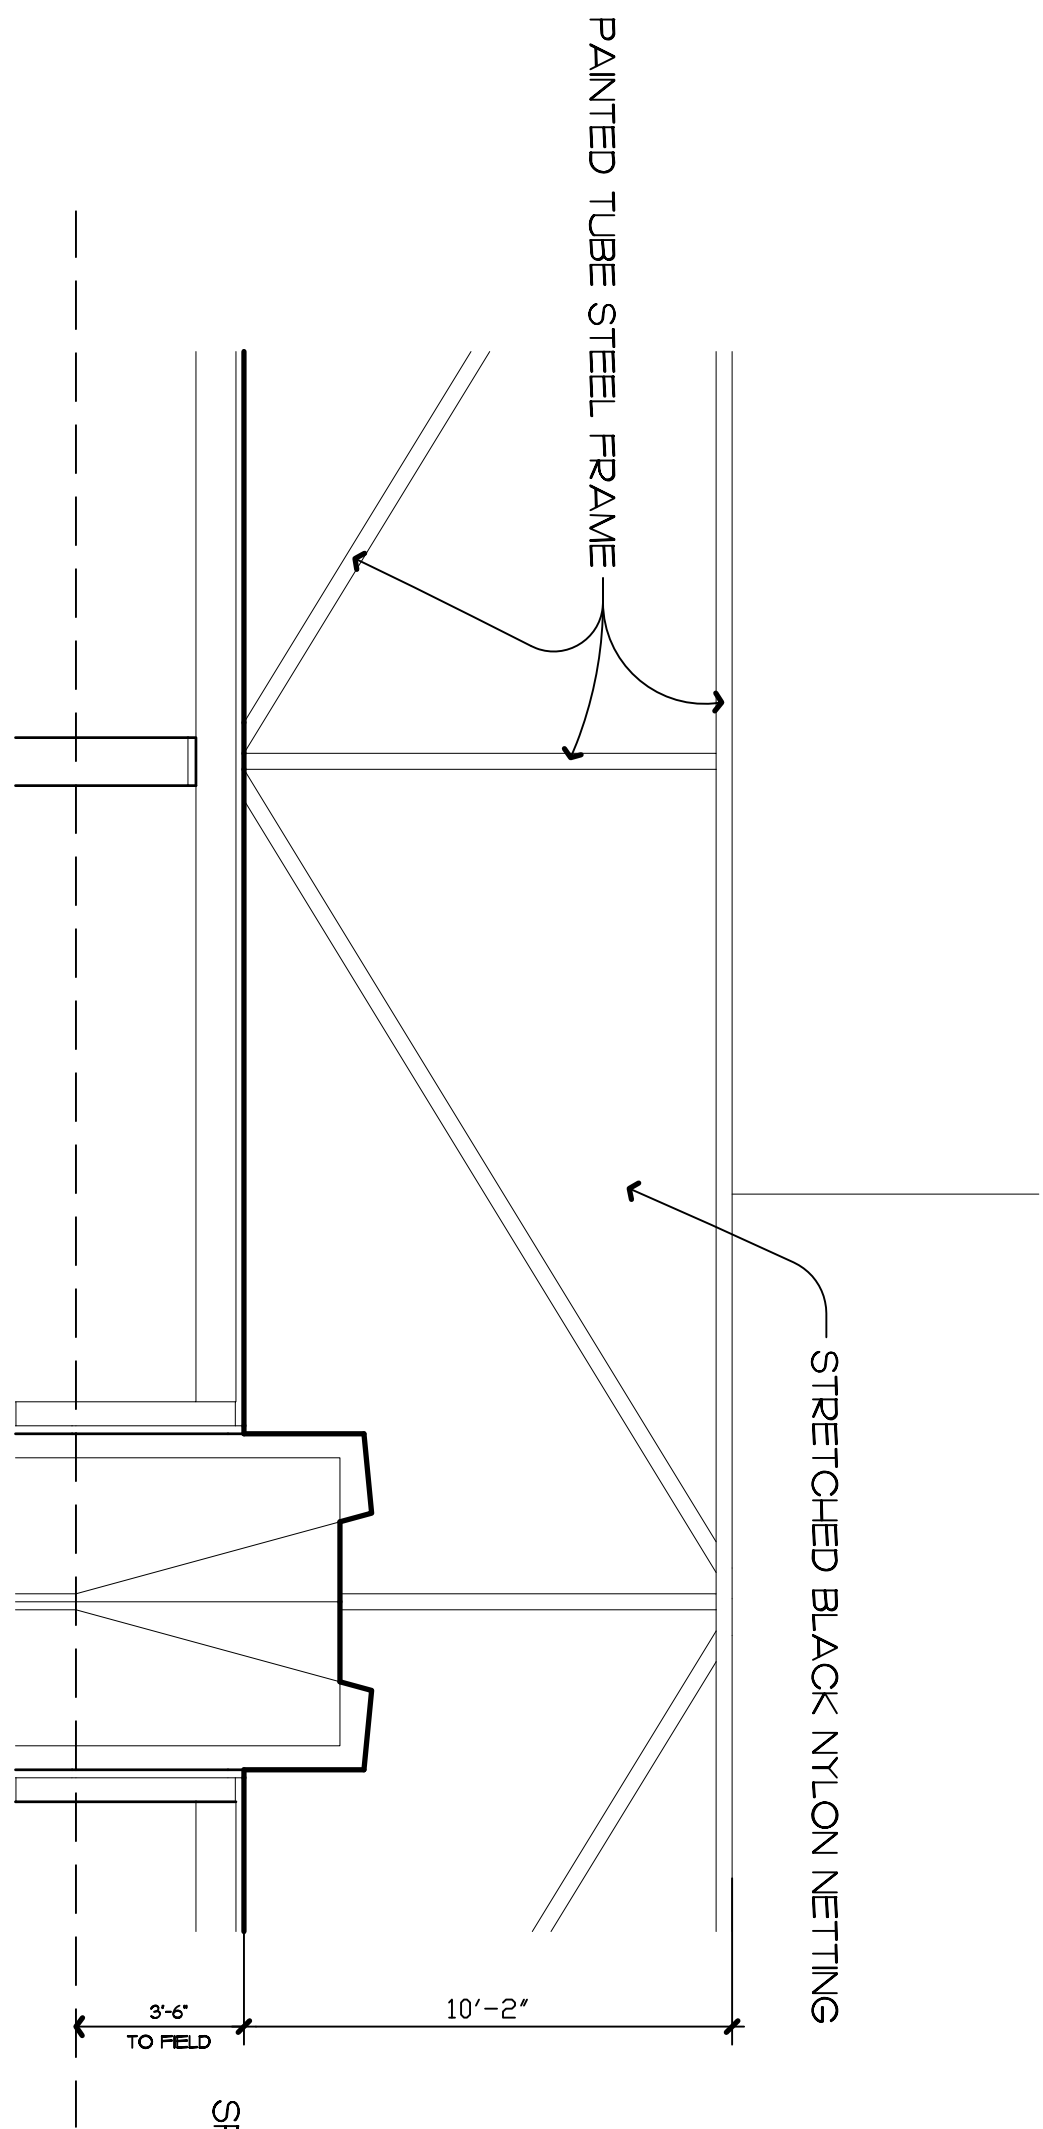


1/16" = 1' - 0"	4
-----------------	---

email | office@uihlein-wilson.com




3
1/16" = 1' - 0"

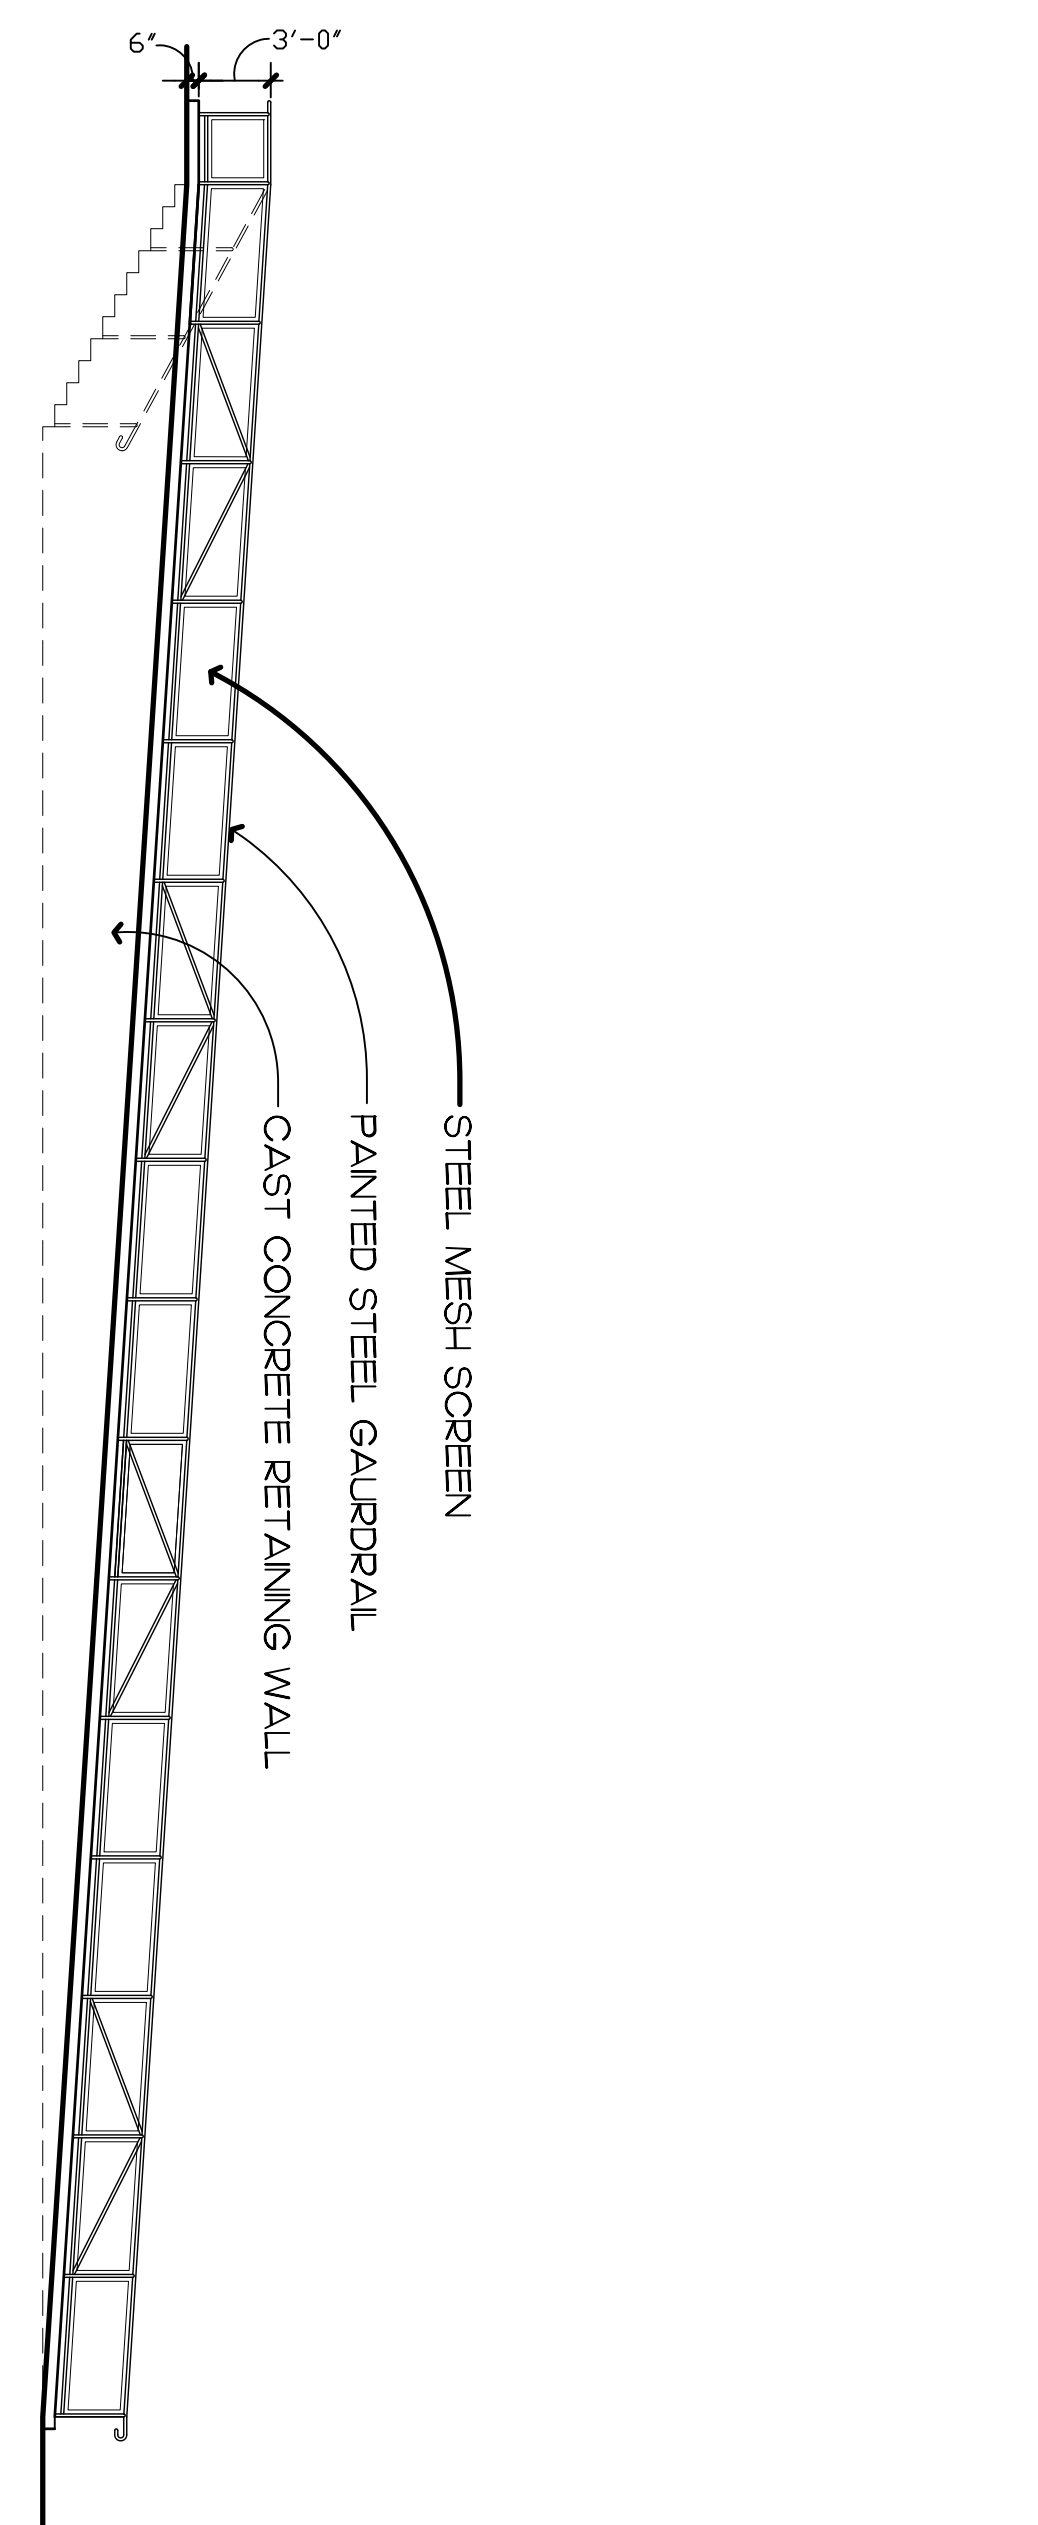

NORTH ELEVATION

2
1/16" = 1'-0"

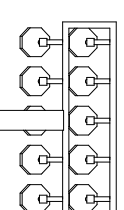2
1/16" = 1'-0"

ELEVATIONS

DATE _____

PROJECT NO.

SHEET NO.

1/16" = 1' - 0"	1
-----------------	---

A-200



**UHLLEIN
WILSON**
ARCHITECTS


322 East Michigan Street
Milwaukee, WI 53202

telephone | 414.271.8899
facsimile | 414.271.8942
email | office@uhllein-wilson.com

© UHLLEIN WILSON ARCHITECTS, INC. ALL RIGHTS RESERVED
THIS DRAWING IS THE PROPERTY OF UHLLEIN WILSON ARCHITECTS, INC. AND IS NOT TO BE REPRODUCED OR TRANSMITTED IN ANY FORM OR BY ANY MEANS, ELECTRONIC OR MECHANICAL, INCLUDING PHOTOCOPYING, RECORDING, OR BY ANY INFORMATION STORAGE AND RETRIEVAL SYSTEM, WITHOUT THE WRITTEN PERMISSION OF UHLLEIN WILSON ARCHITECTS, INC.


REVISIONS		
NO.	DATE	NOTE

MATERIAL LEGEND	
	BRICK
	ARCHITECTURAL PRECAST
	GLAZING
	SPANDREL
	METAL WALL PANEL

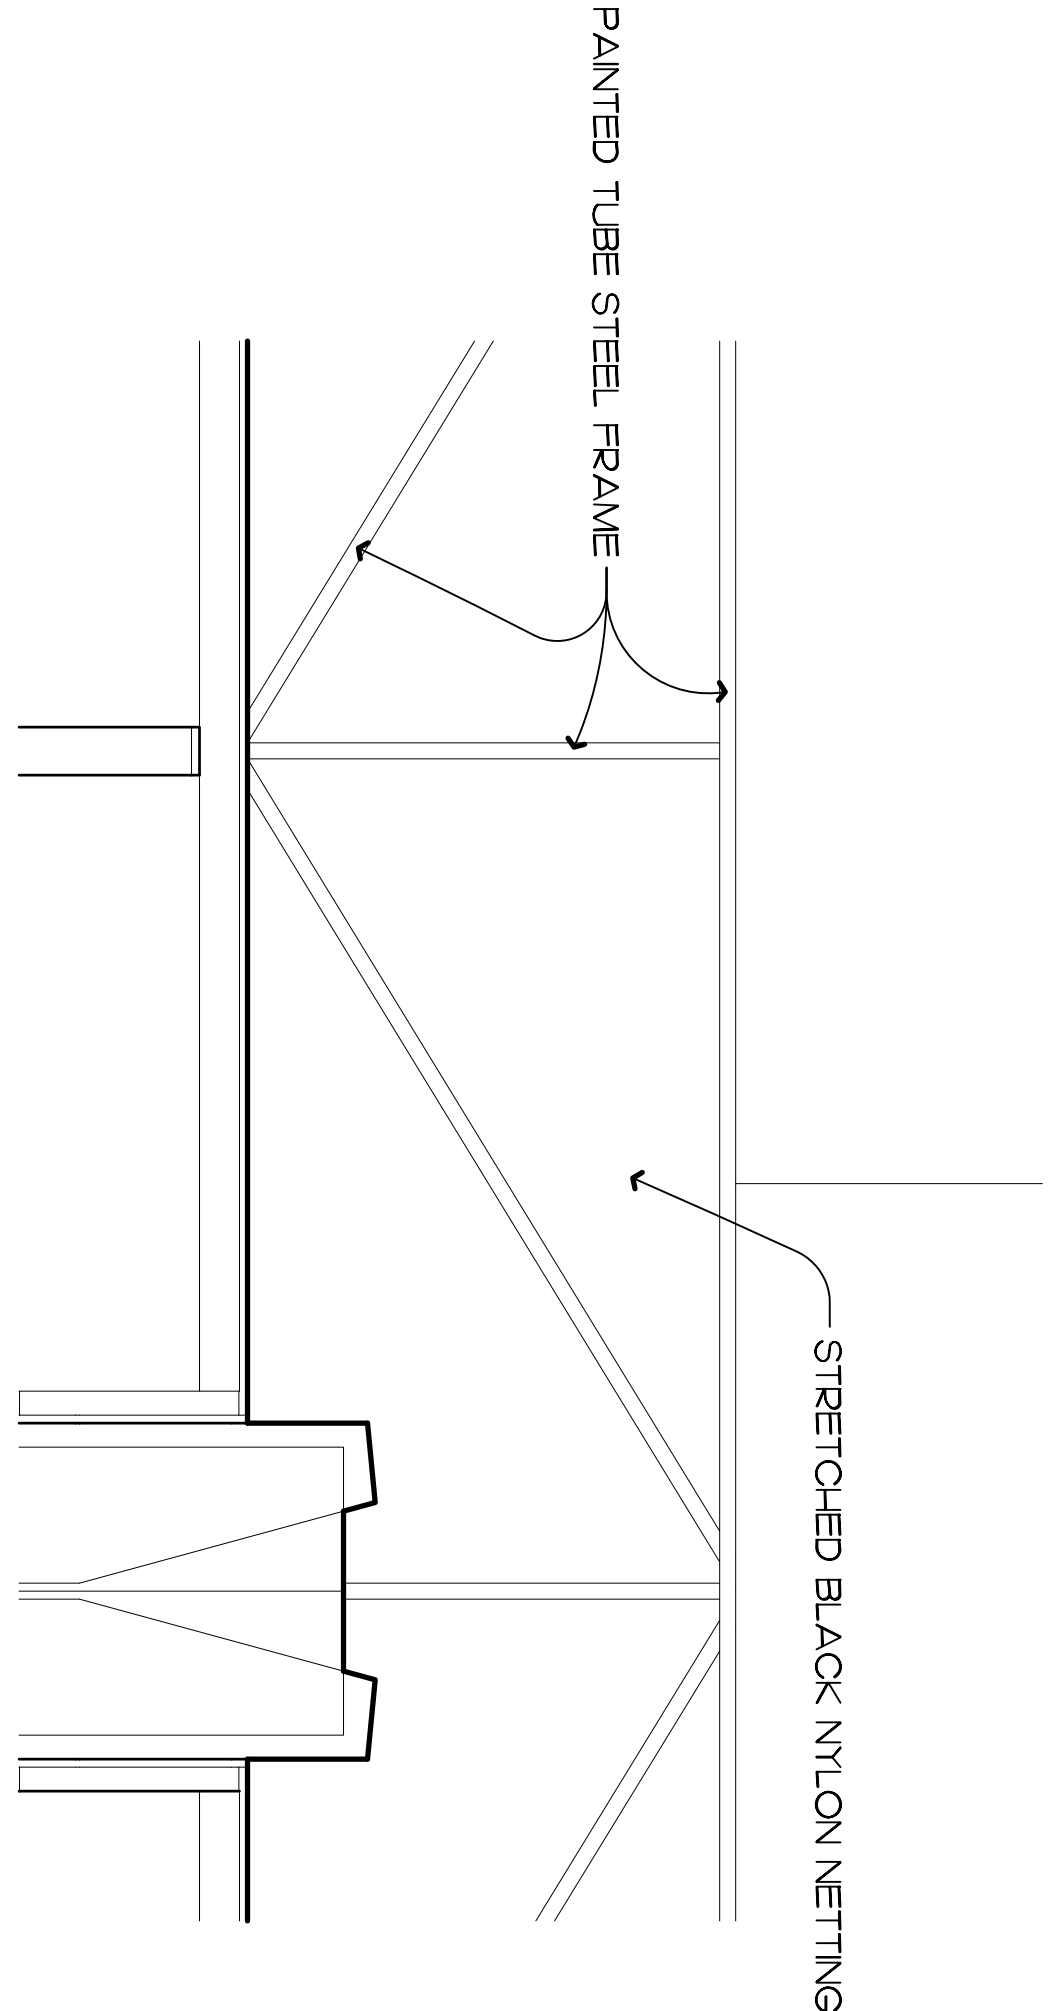


NETTING FRAME DETAIL

1/4" = 1'-0"

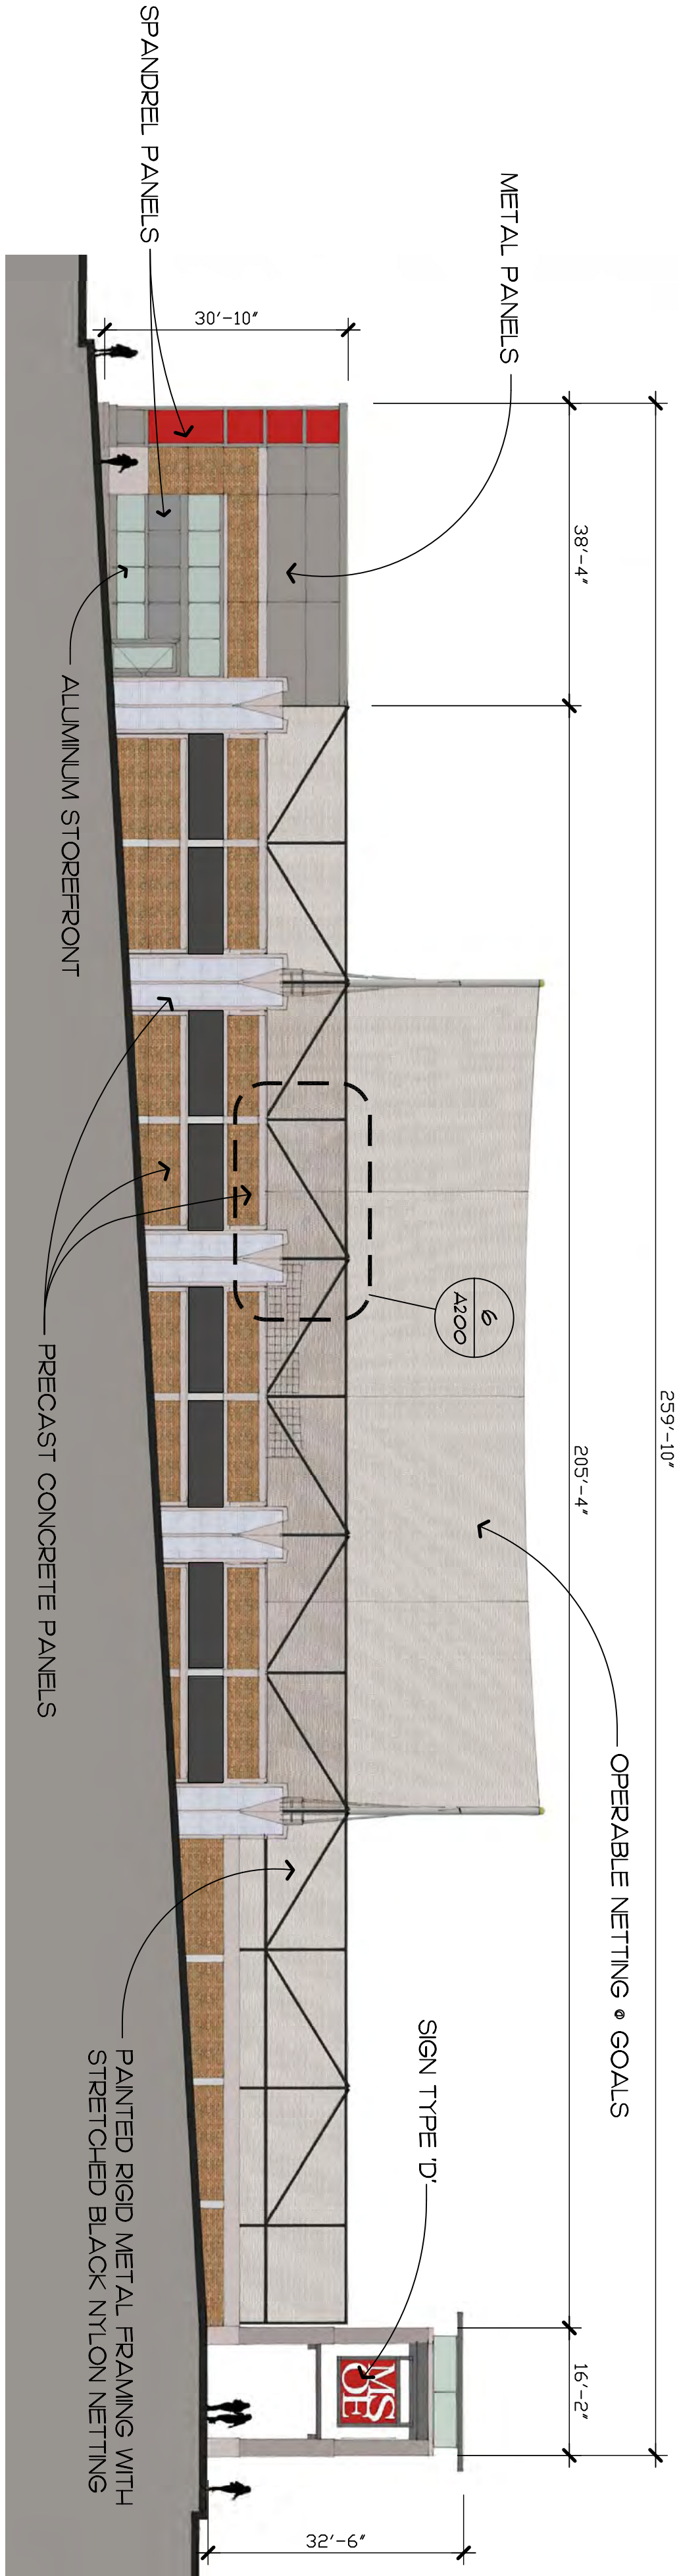


SOUTH ELEVATION

1/16" = 1'-0"

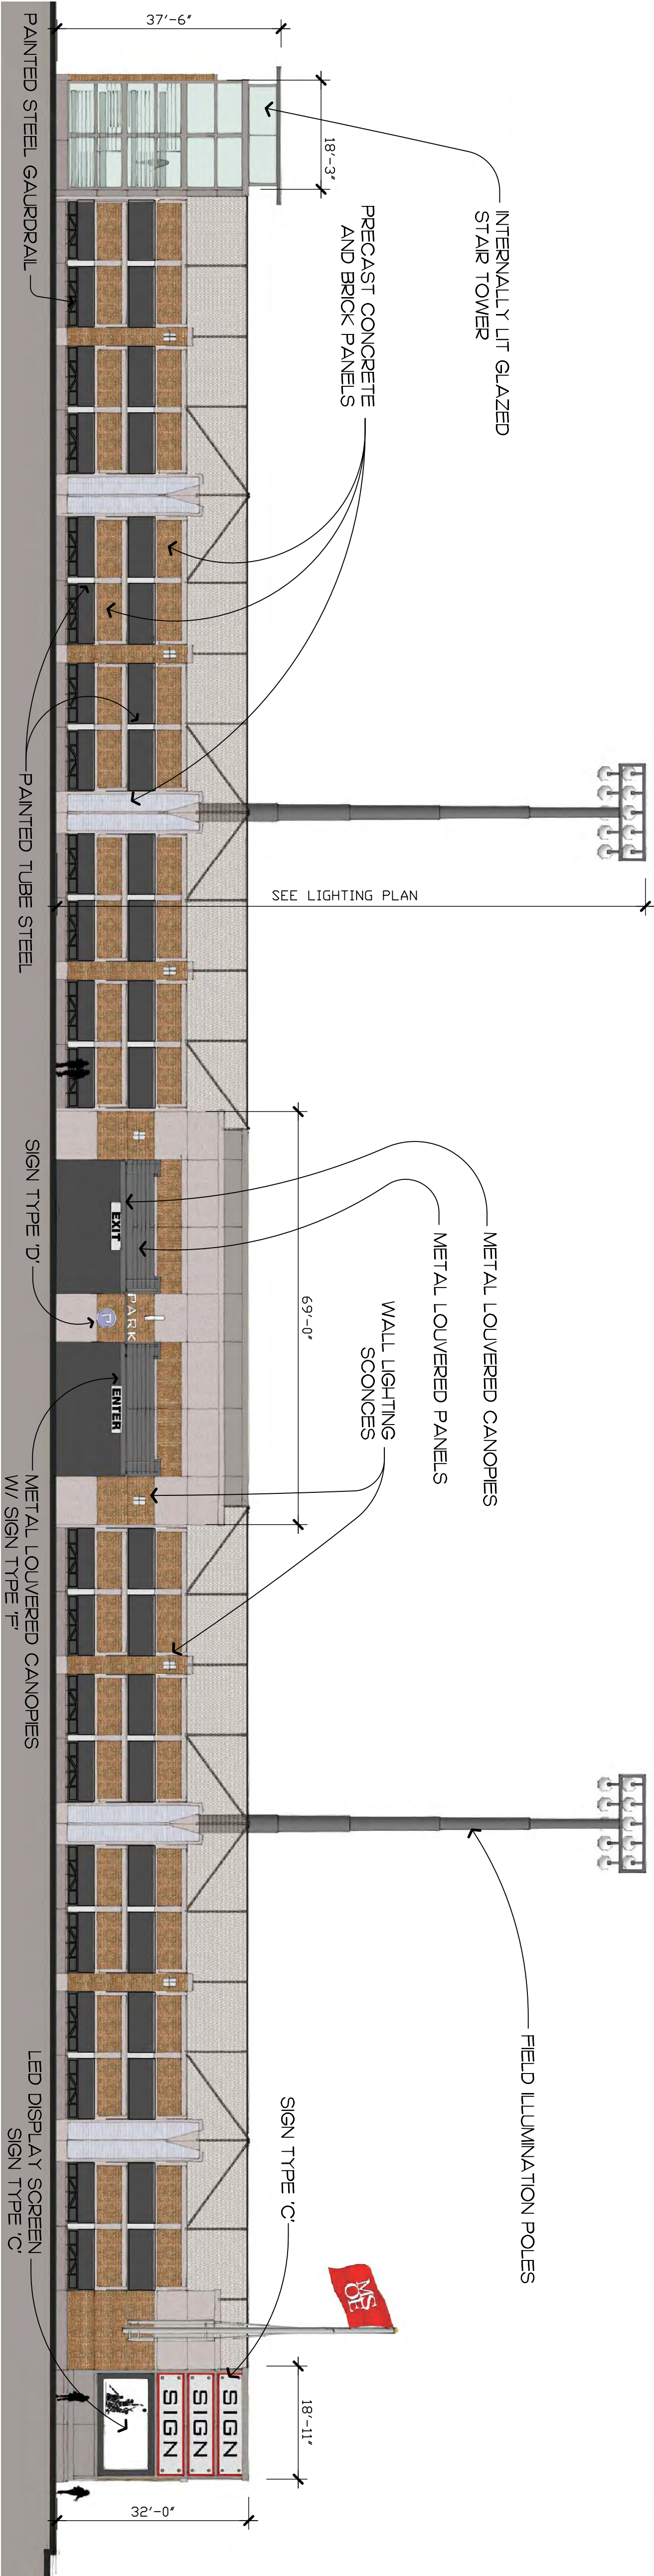


WEST ELEVATION

1/16" = 1'-0"

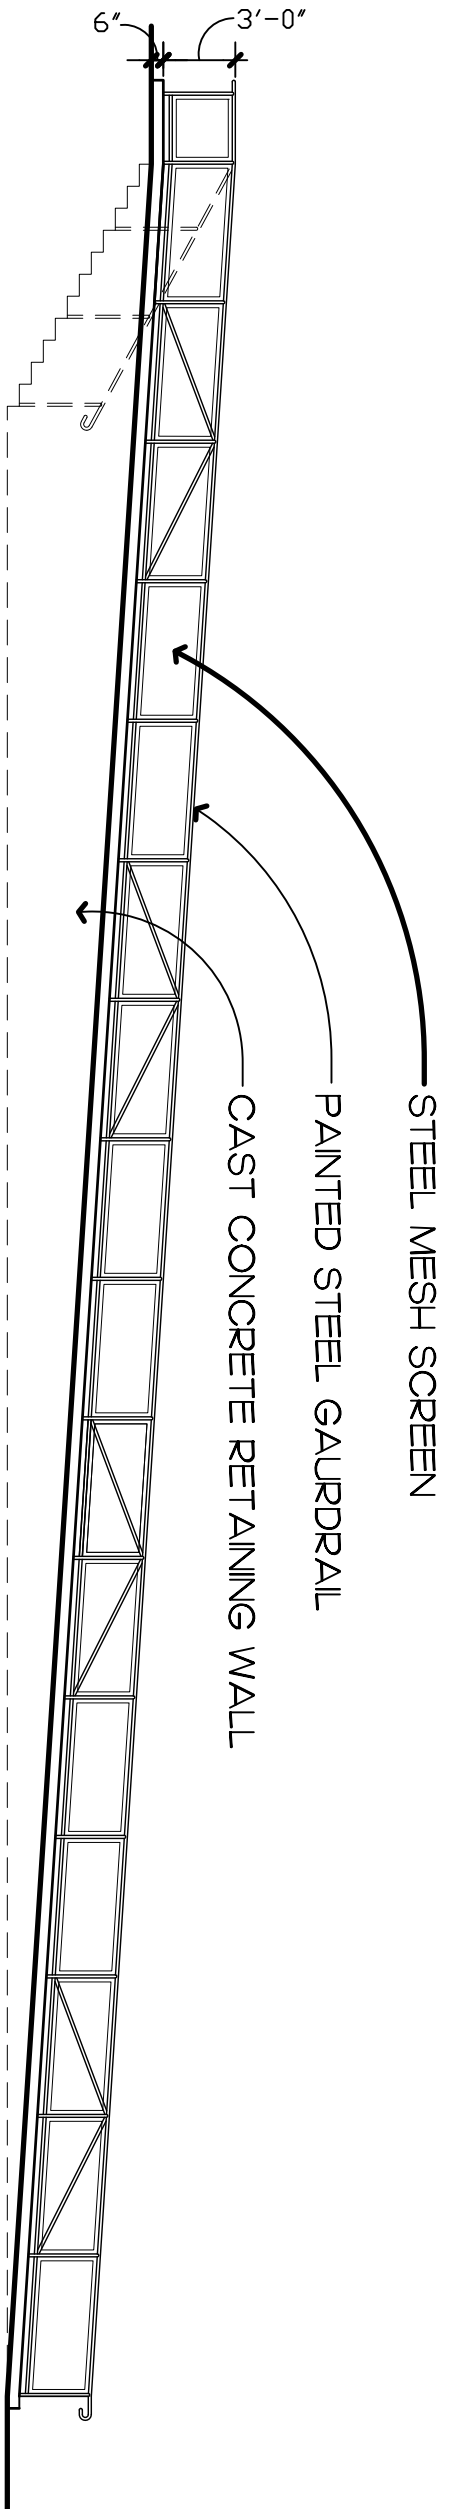


NETTING FRAME DETAIL

1/8" = 1'-0"

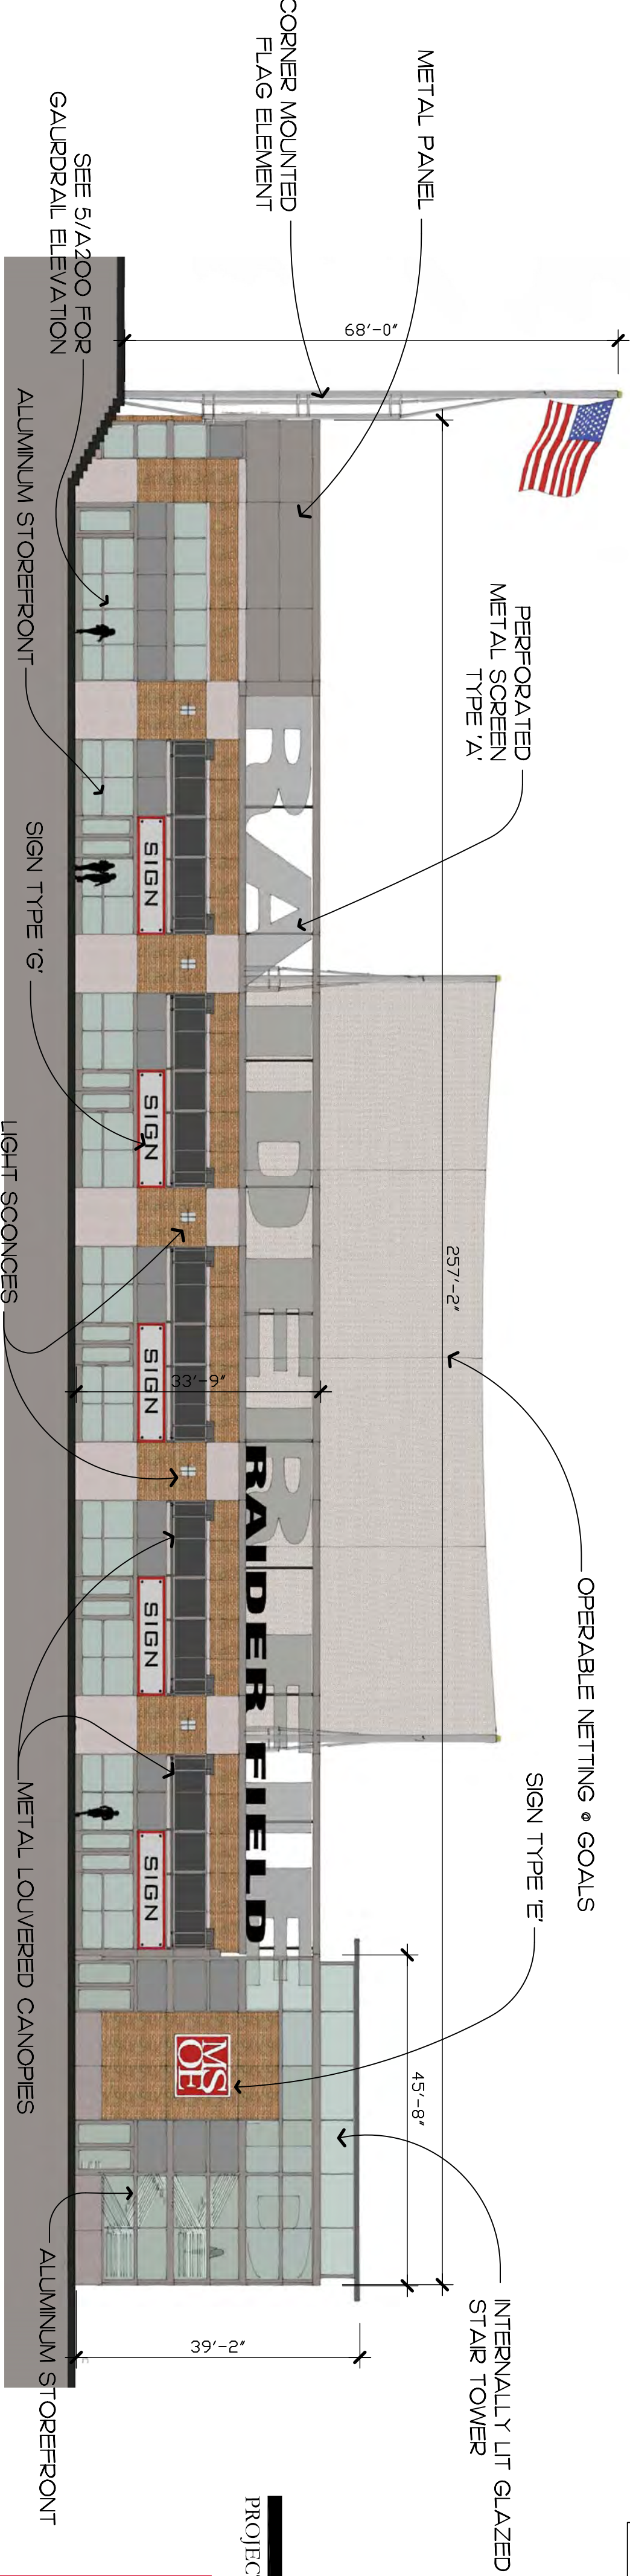

NORTH ELEVATION

1/16" = 1'-0"

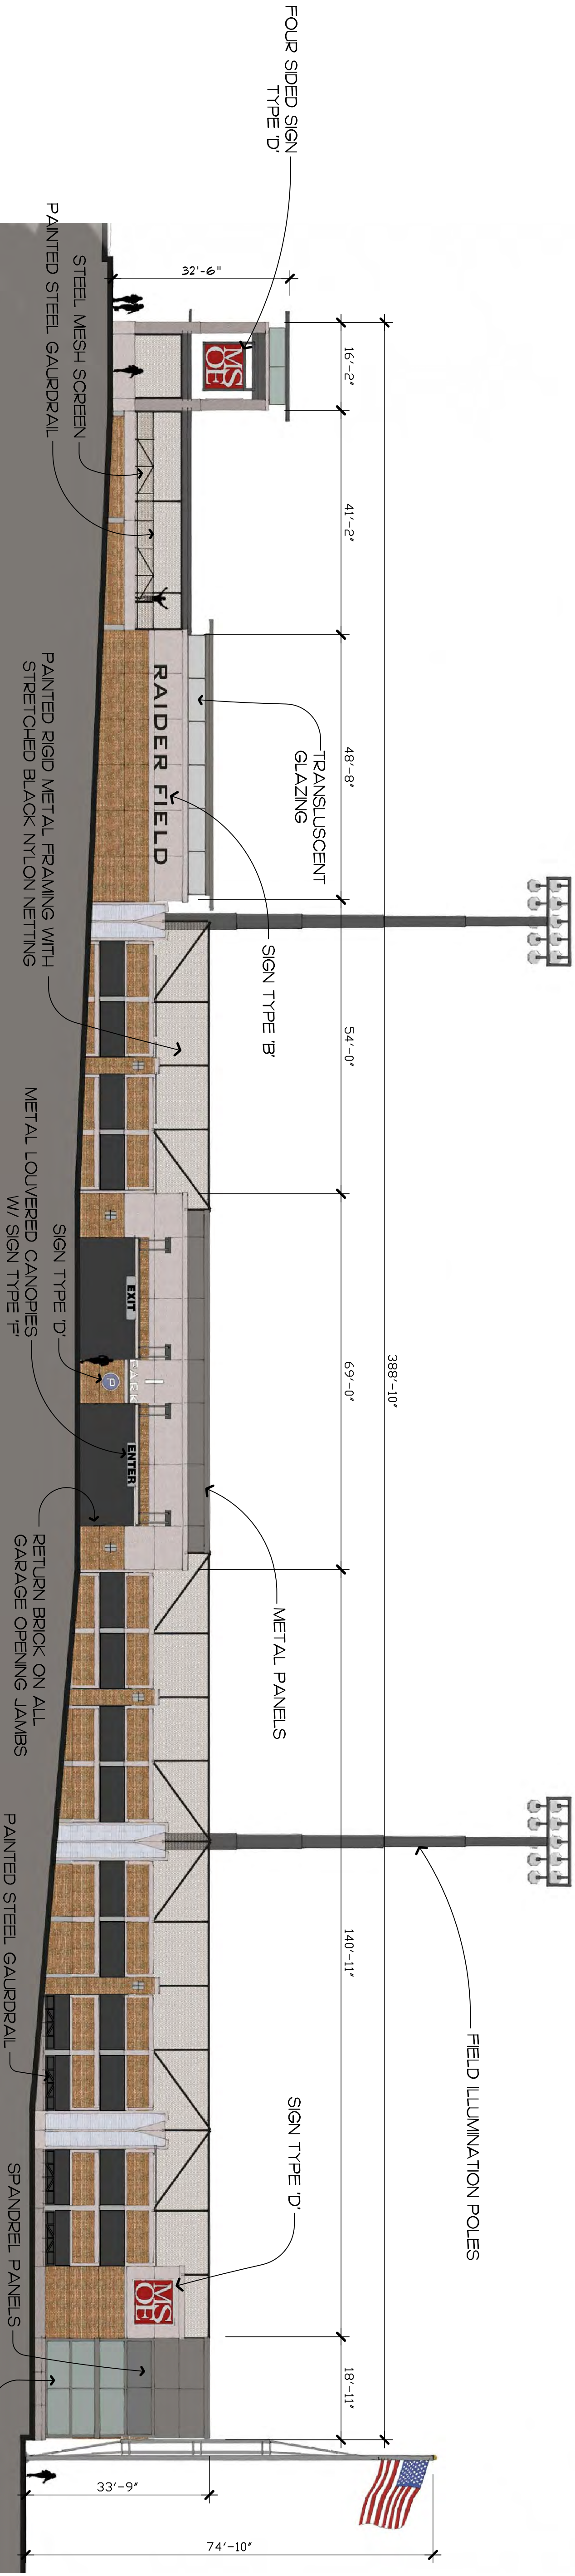

EAST ELEVATION

1/16" = 1'-0"



Proposed MSOE
SOCCER & PARKING
FACILITY

SHEET

ELEVATIONS

DATE
May 9, 2011

PROJECT NO.
09-117

SHEET NO.

A-200



**UHLLEIN
WILSON**
ARCHITECTS
322 East Michigan Street
Milwaukee, WI 53202
telephone | 414.271.8899
facsimile | 414.271.8942
email | office@uhllein-wilson.com

© UHLEIN WILSON ARCHITECTS, INC. ALL RIGHTS RESERVED
THIS SHEET IS THE PROPERTY OF UHLLEIN WILSON ARCHITECTS, INC. IT IS TO BE USED ONLY FOR THE PROJECT AND SITE SPECIFICALLY IDENTIFIED HEREON. IT IS NOT TO BE REPRODUCED, COPIED, OR TRANSMITTED IN ANY FORM OR BY ANY MEANS, ELECTRONIC OR MECHANICAL, INCLUDING PHOTOCOPYING, RECORDING, OR BY ANY INFORMATION STORAGE AND RETRIEVAL SYSTEM, WITHOUT THE WRITTEN PERMISSION OF UHLLEIN WILSON ARCHITECTS, INC.

REVISIONS
NO. DATE ISSUE



Proposed MSOE
SOCCER & PARKING
FACILITY




SHEET

SIGNAGE



DATE
May 9, 2011
PROJECT NO.
09-117

SHEET NO.


A-201

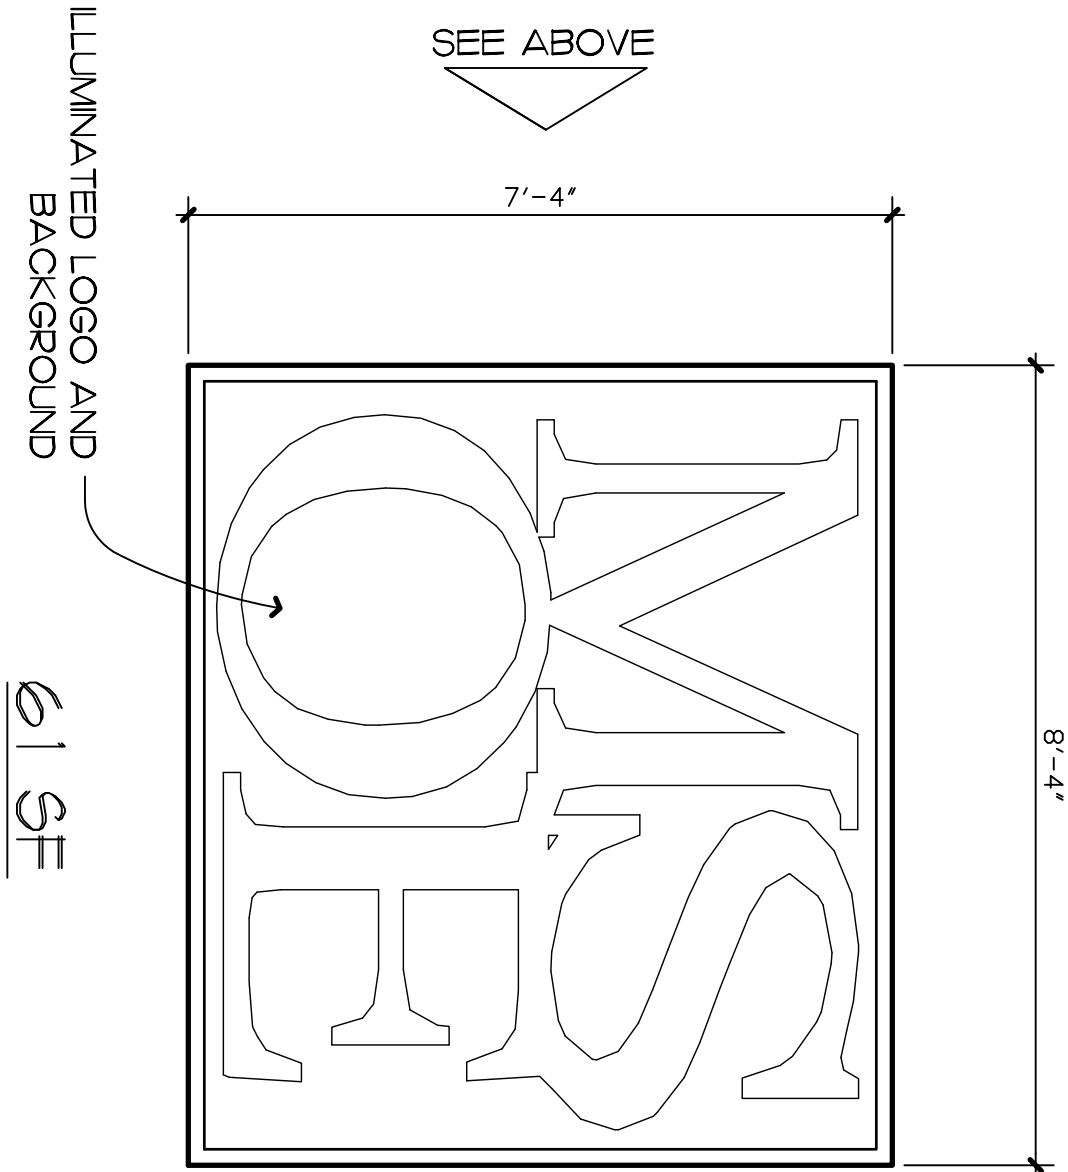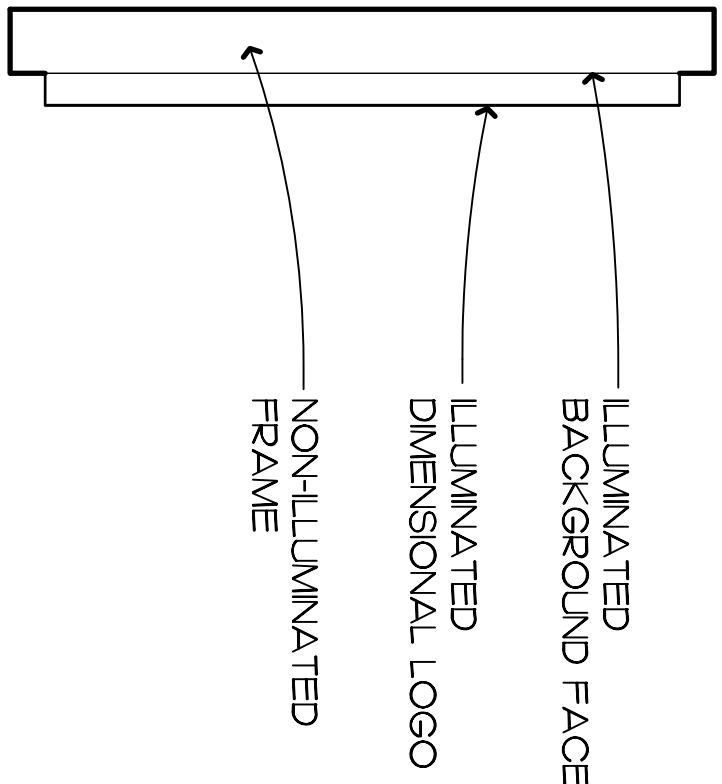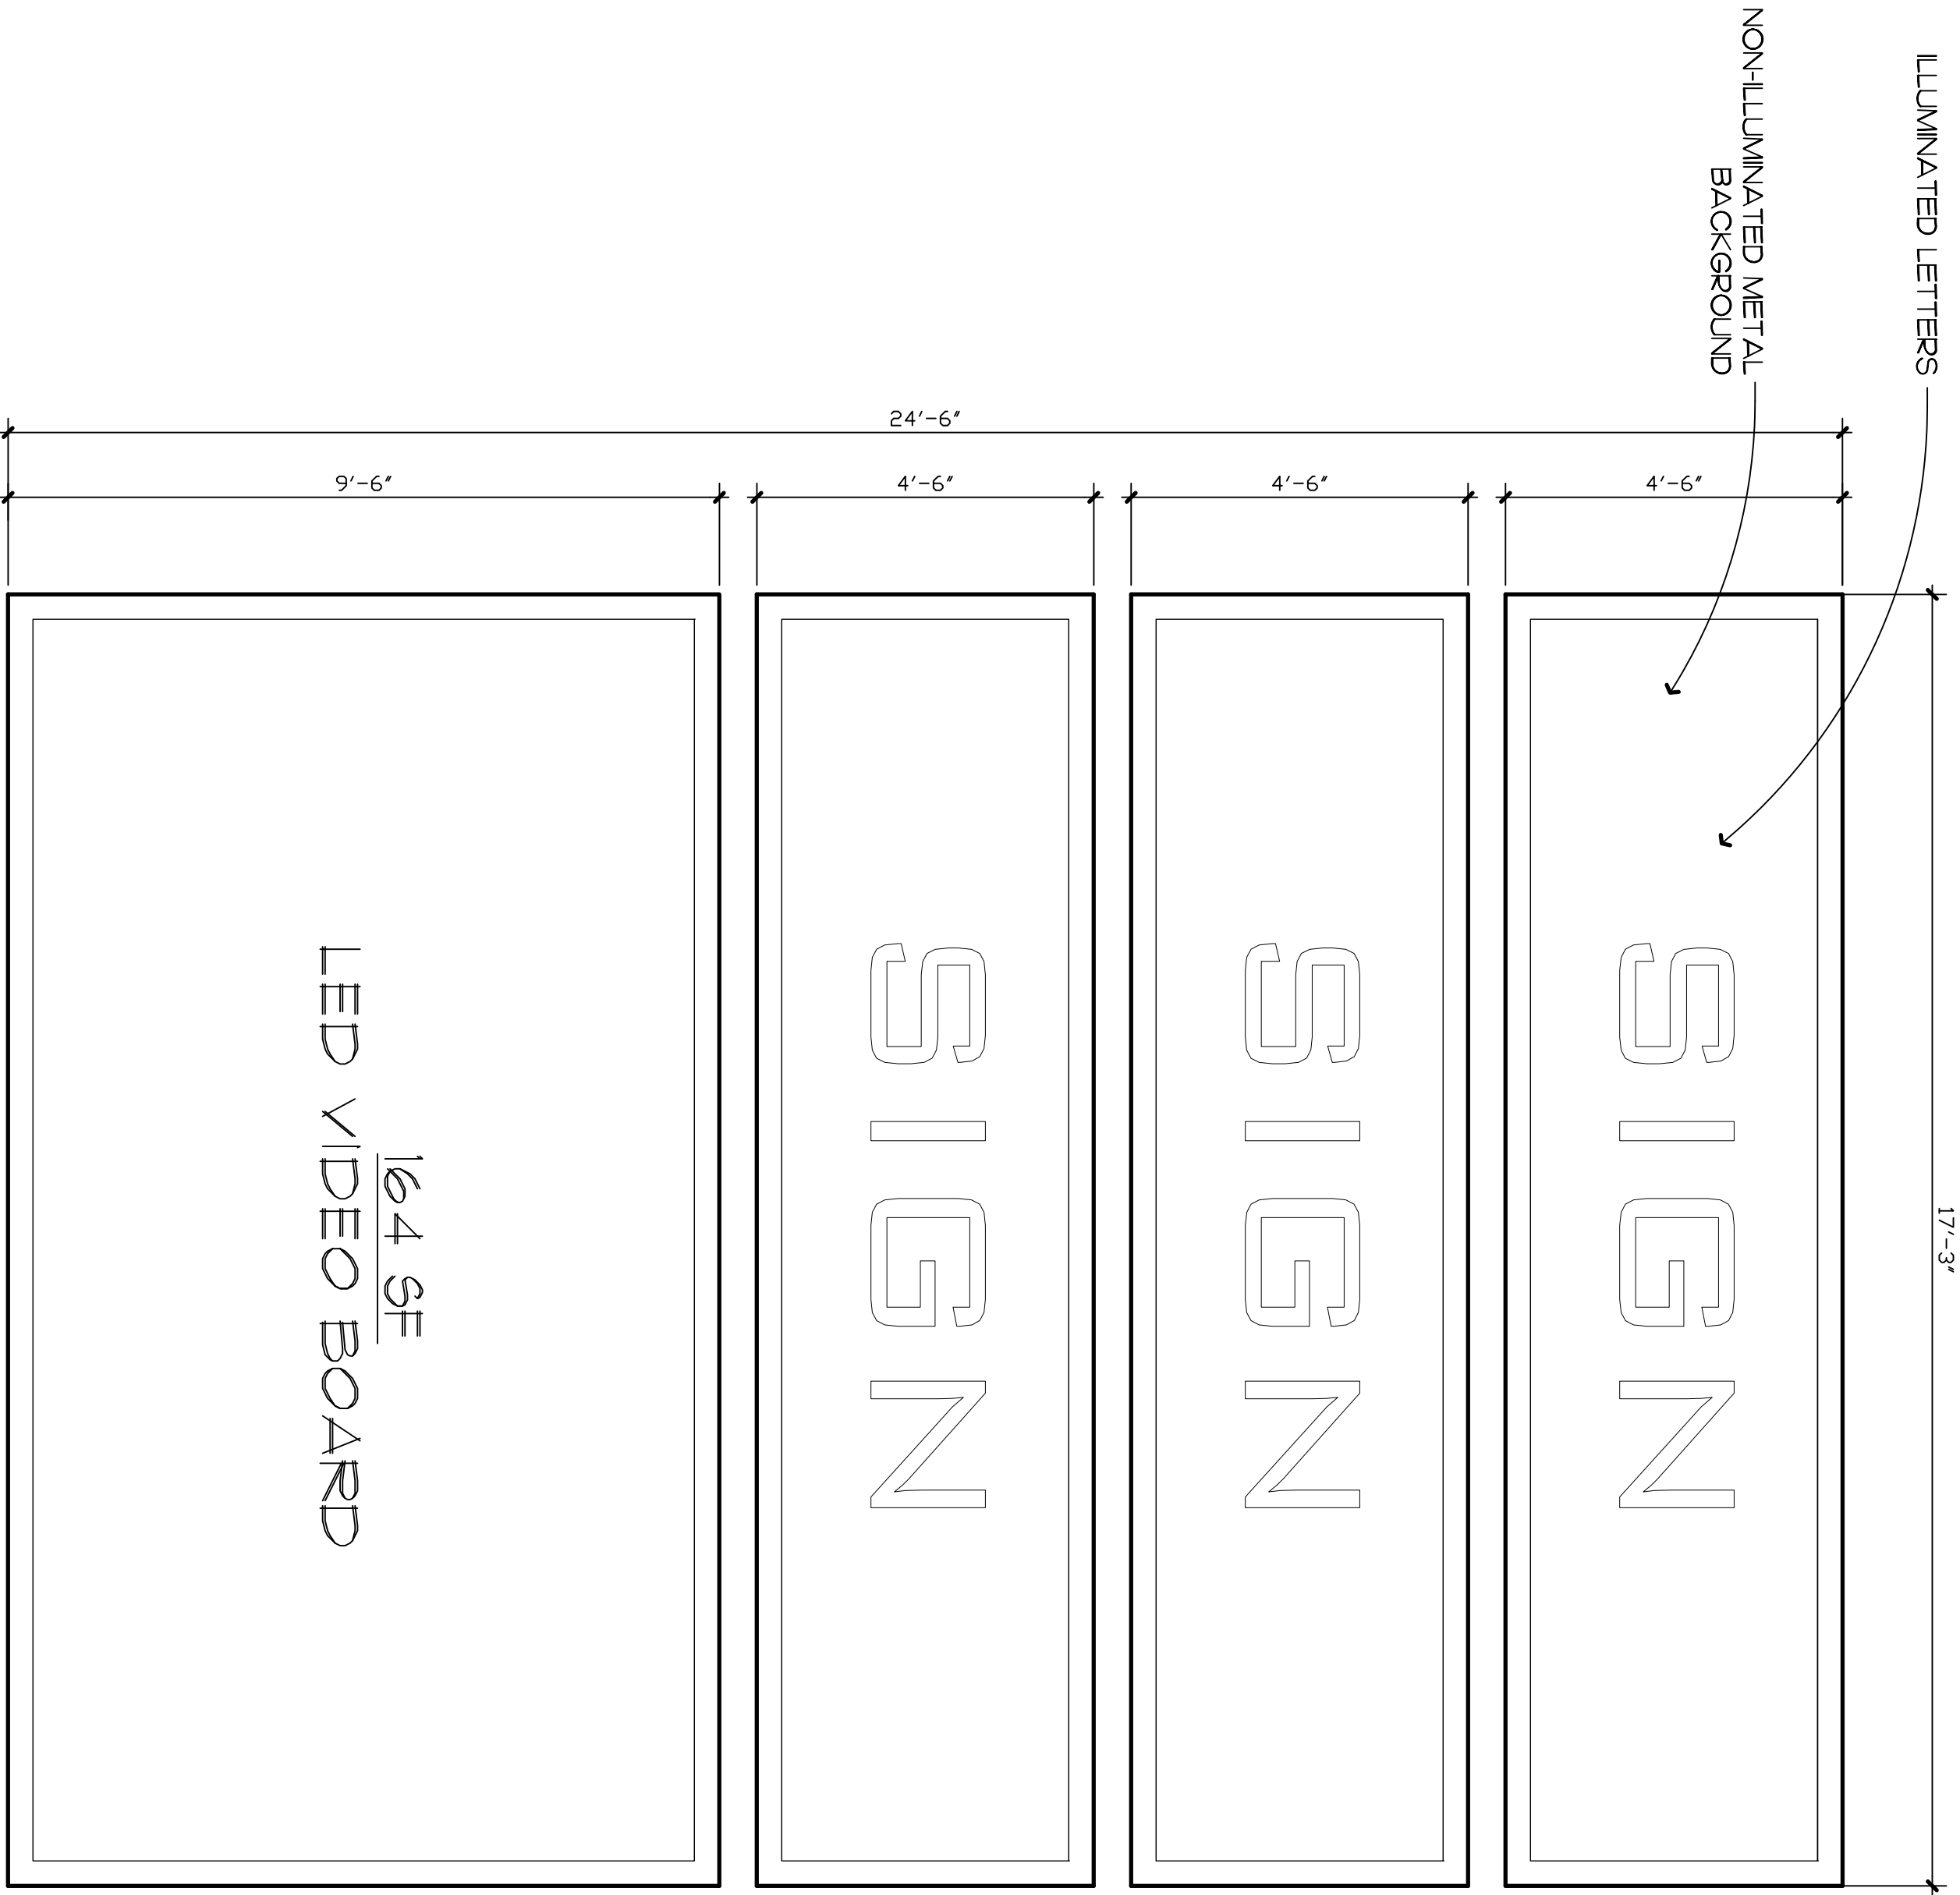


SIGN ELEVATION - E 1/2" = 1'-0" 5

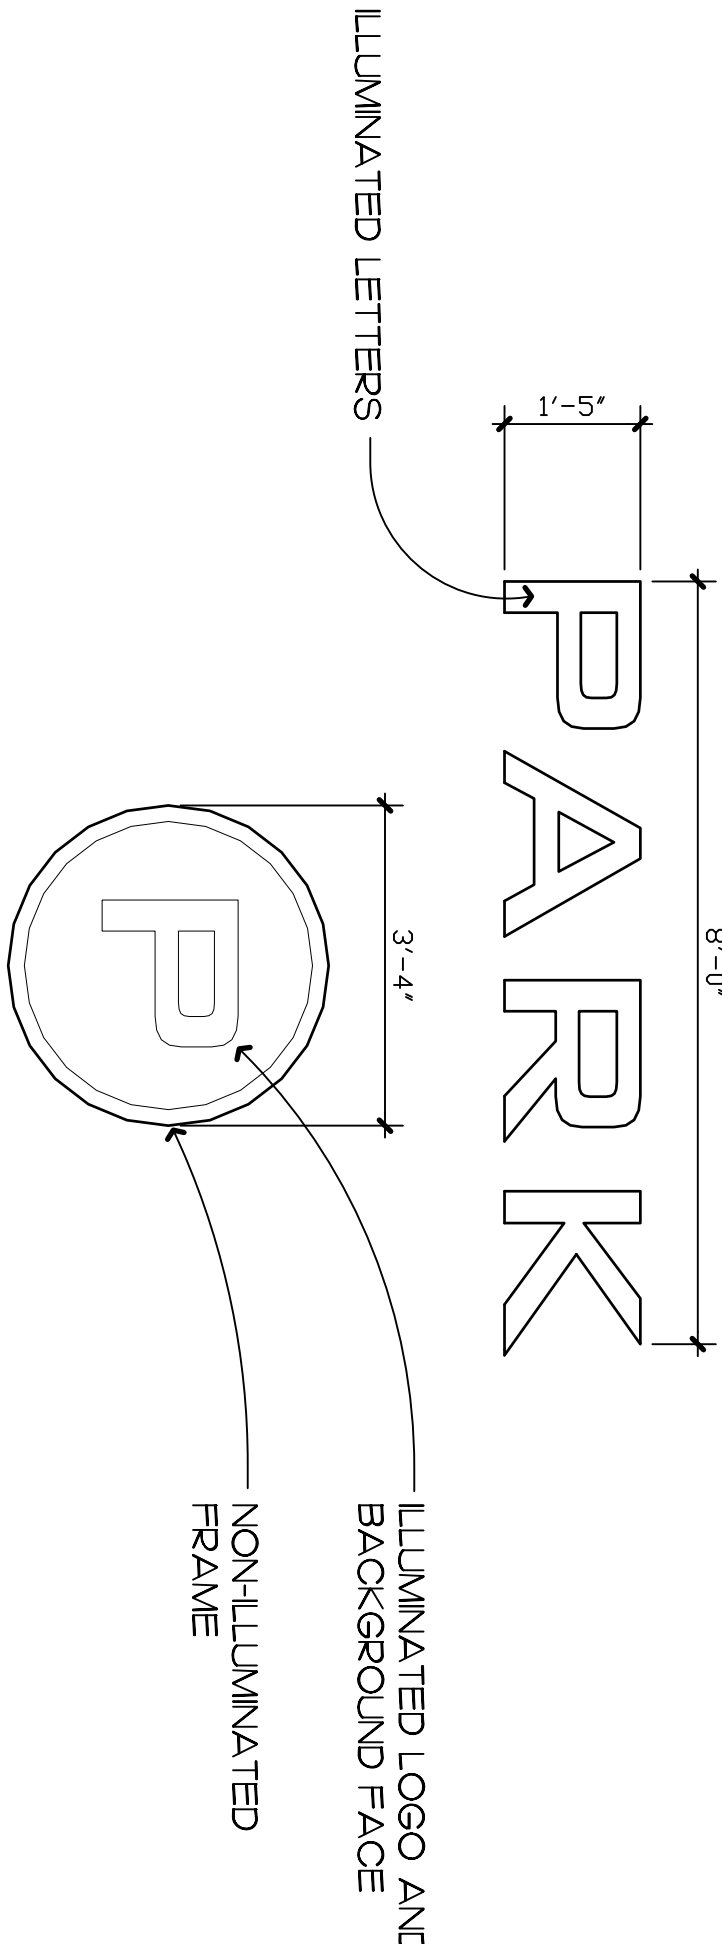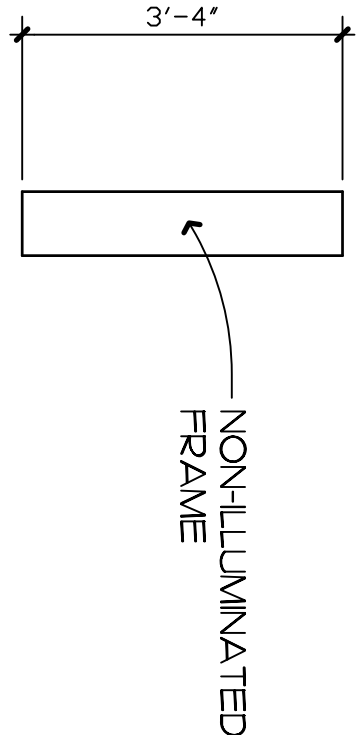


SIGN ELEVATION - D 1/2" = 1'-0" 4

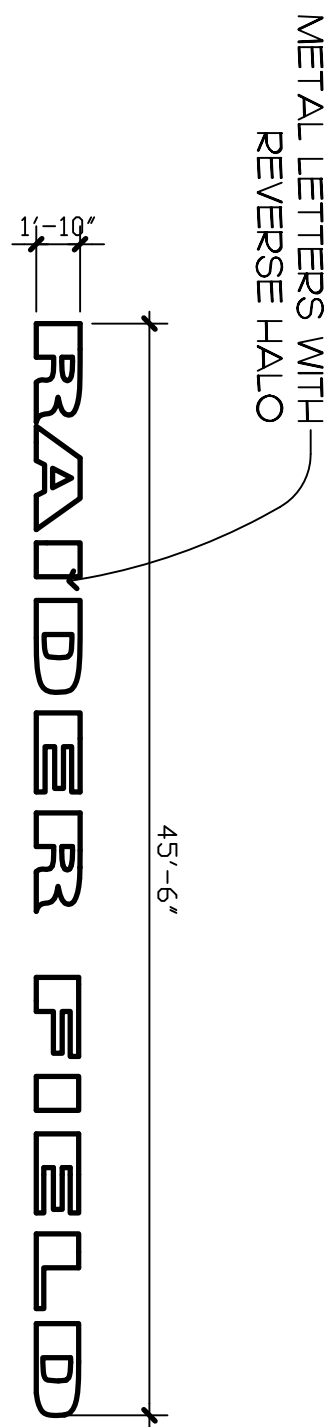


SIGN ELEVATION - B 1/2" = 1'-0" 2

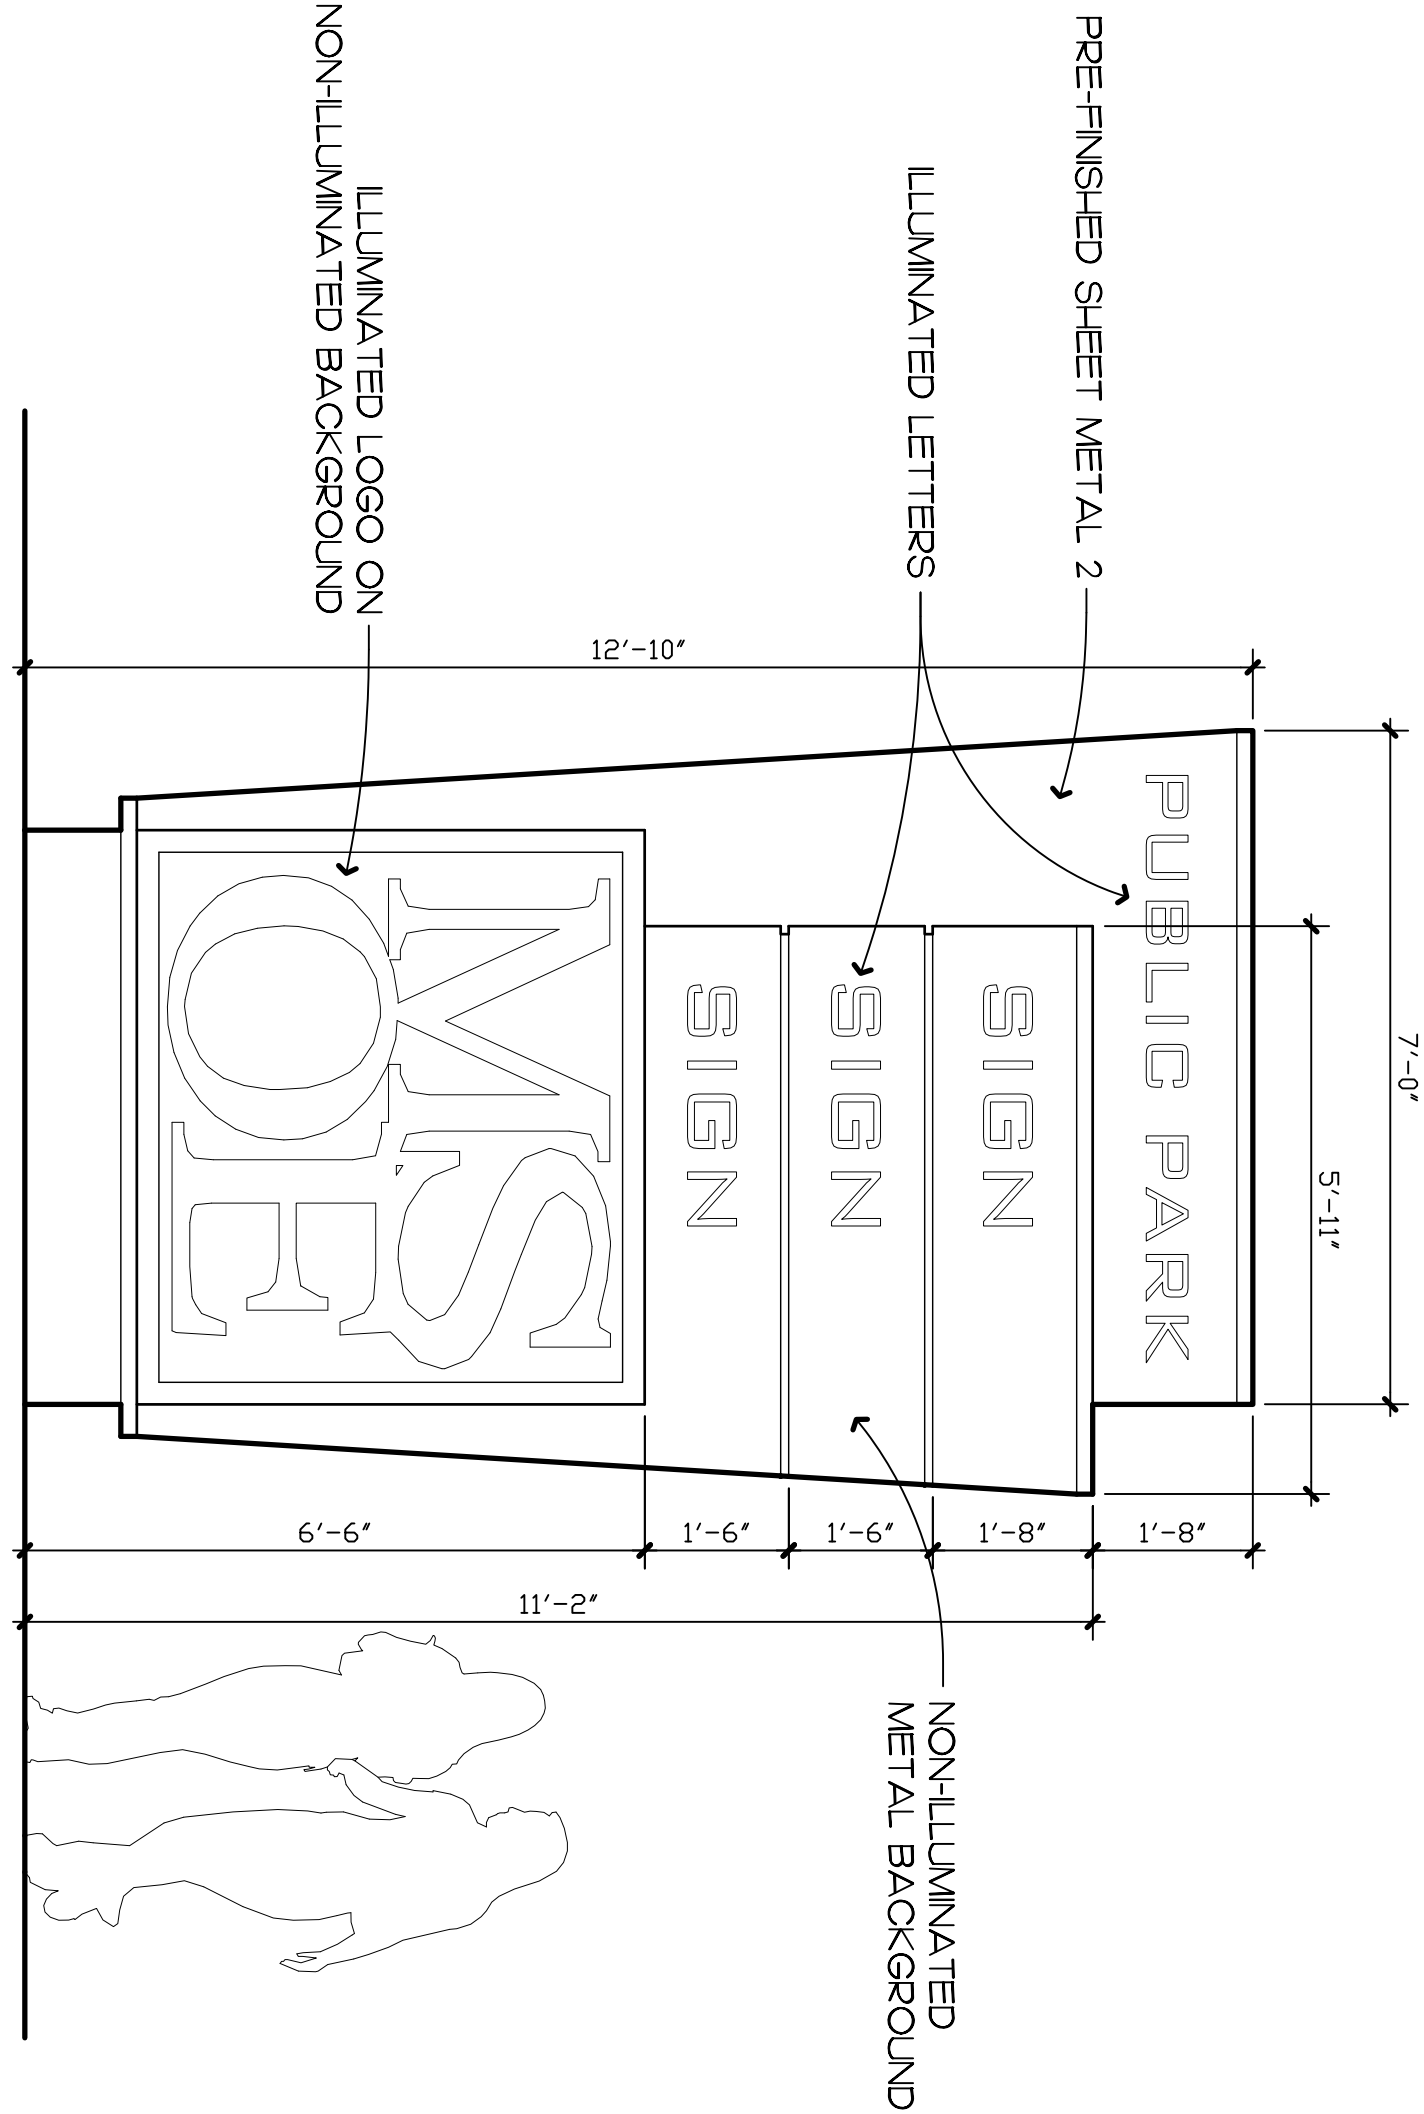


SIGN ELEVATION - H 1/2" = 1'-0" 8

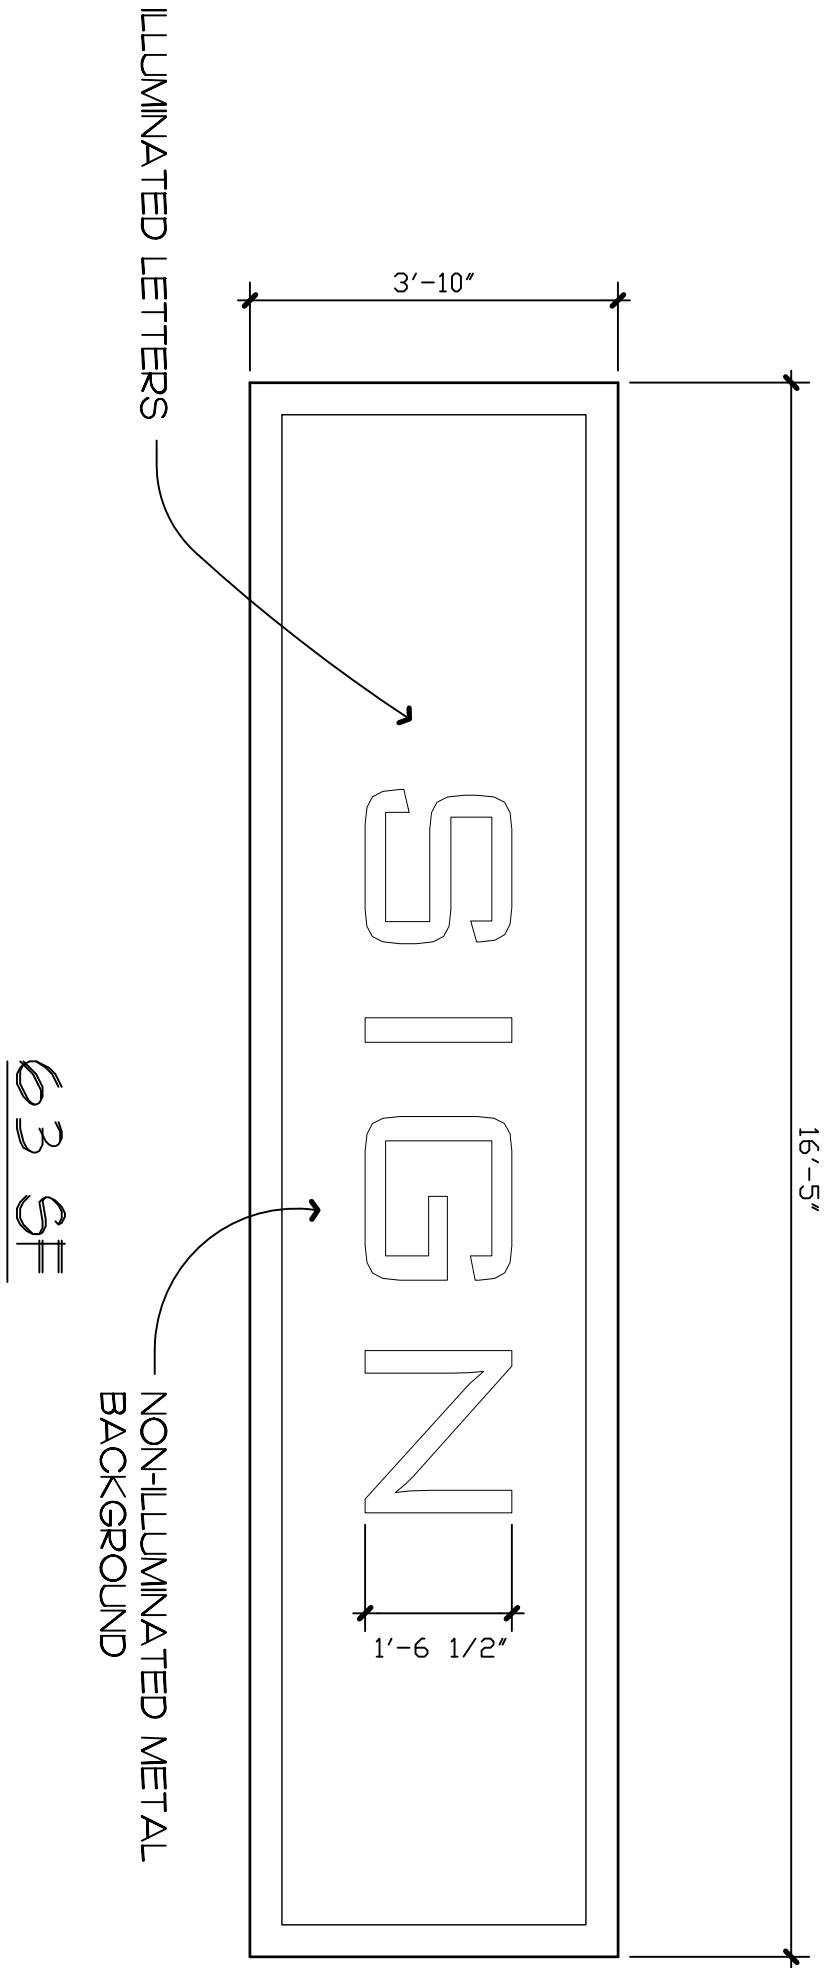

SIGN ELEVATION - G 1/2" = 1'-0" 7

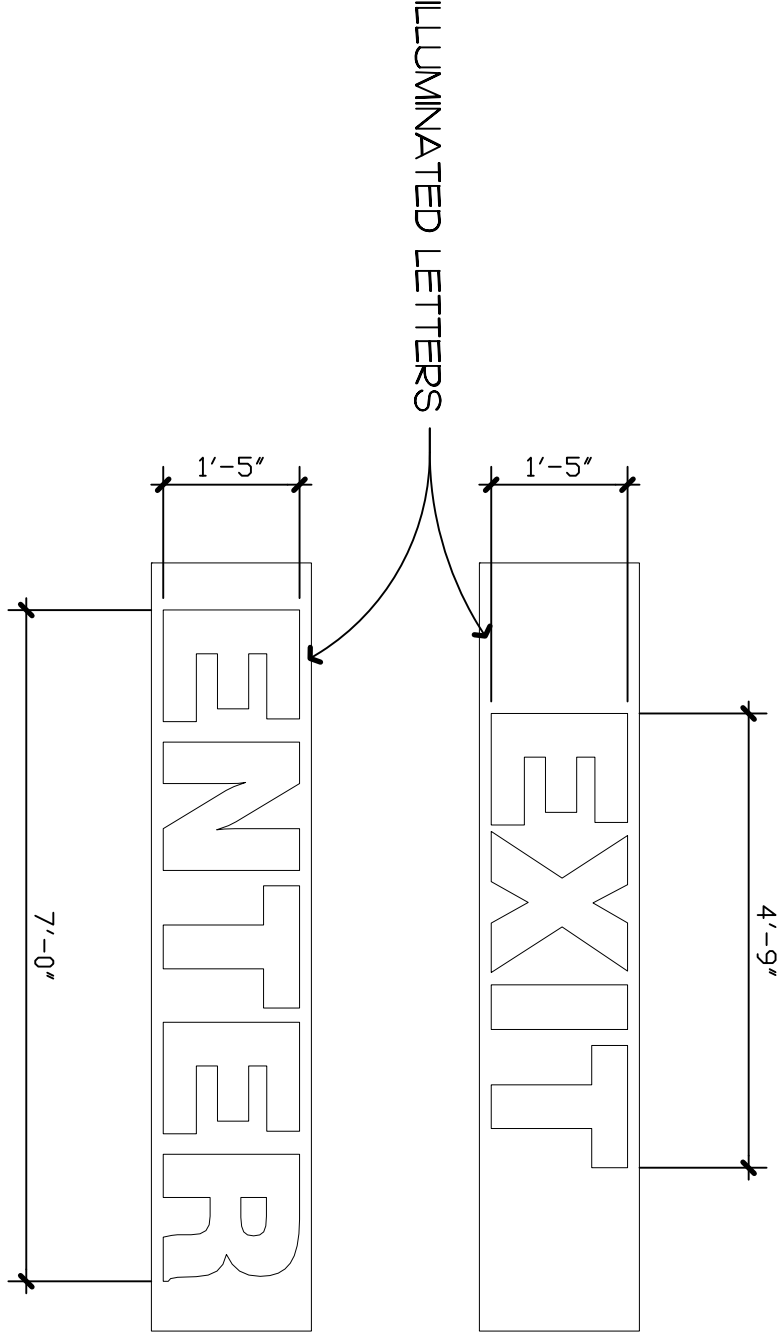

SIGN ELEVATION - F 1/2" = 1'-0" 6

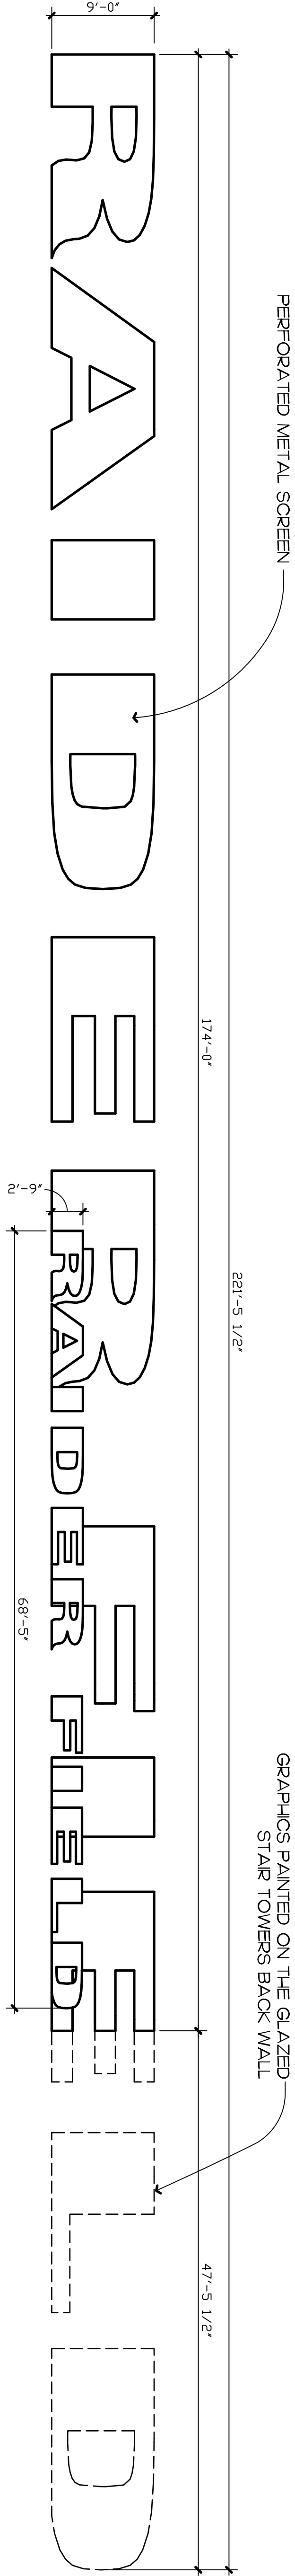

SIGN ELEVATION - A 1/8" = 1'-0" 1



**UHLEIN
WILSON**
ARCHITECTS

322 East Michigan Street
Milwaukee, WI 53202

telephone | 414.271.8899
facsimile | 414.271.8942
email | office@uhllein-wilson.com

© UHLEIN WILSON ARCHITECTS, INC. ALL RIGHTS RESERVED.
THE FIRM OF UHLEIN WILSON ARCHITECTS, INC. IS AN EQUAL OPPORTUNITY FIRM.
This drawing is the property of Uhllein Wilson Architects, Inc. and is not to be used in whole or in part
without the written consent of Uhllein Wilson Architects, Inc.

REVISIONS		
NO.	DATE	NOTE

PROJECT



Proposed MSOE
SOCCER & PARKING
FACILITY

SHEET

ELEVATIONS

DATE


May 9, 2011

PROJECT NO.

09-117

SHEET NO.


A-300

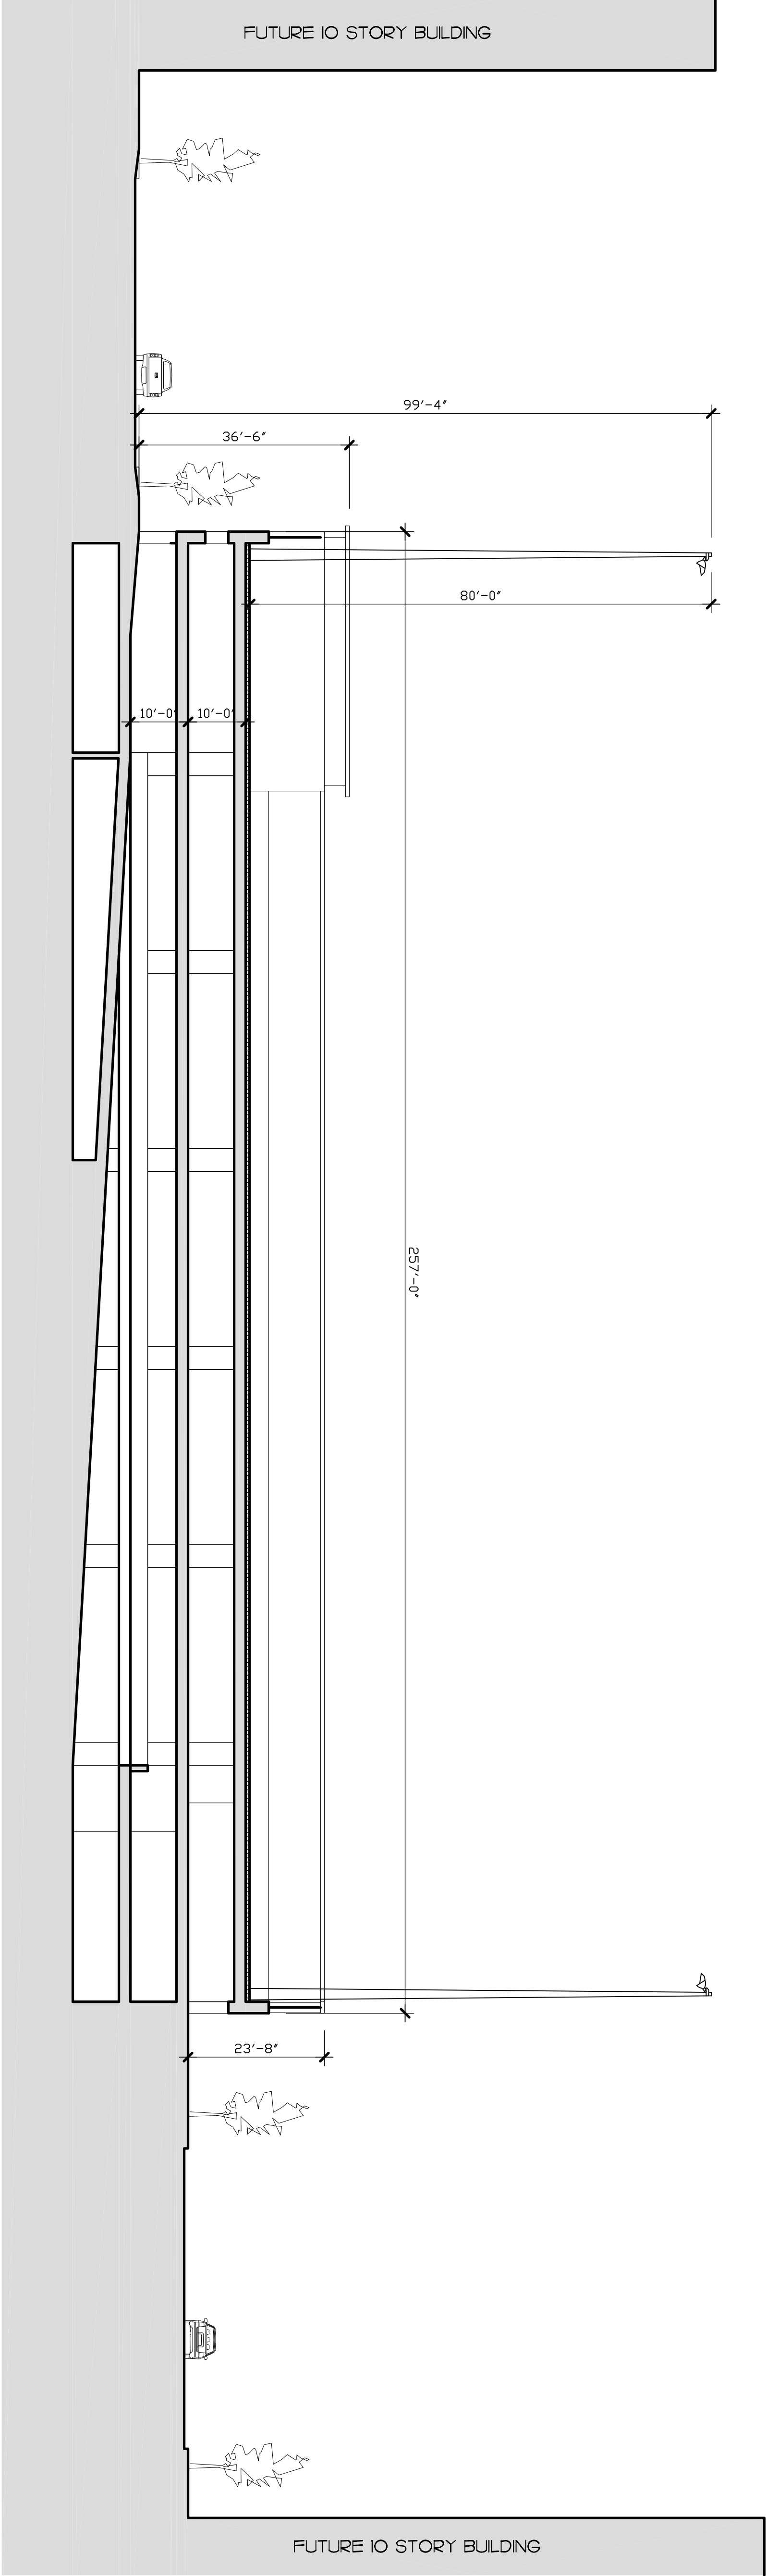

EAST/WEST SECTION

1/8" = 1'-0"

2

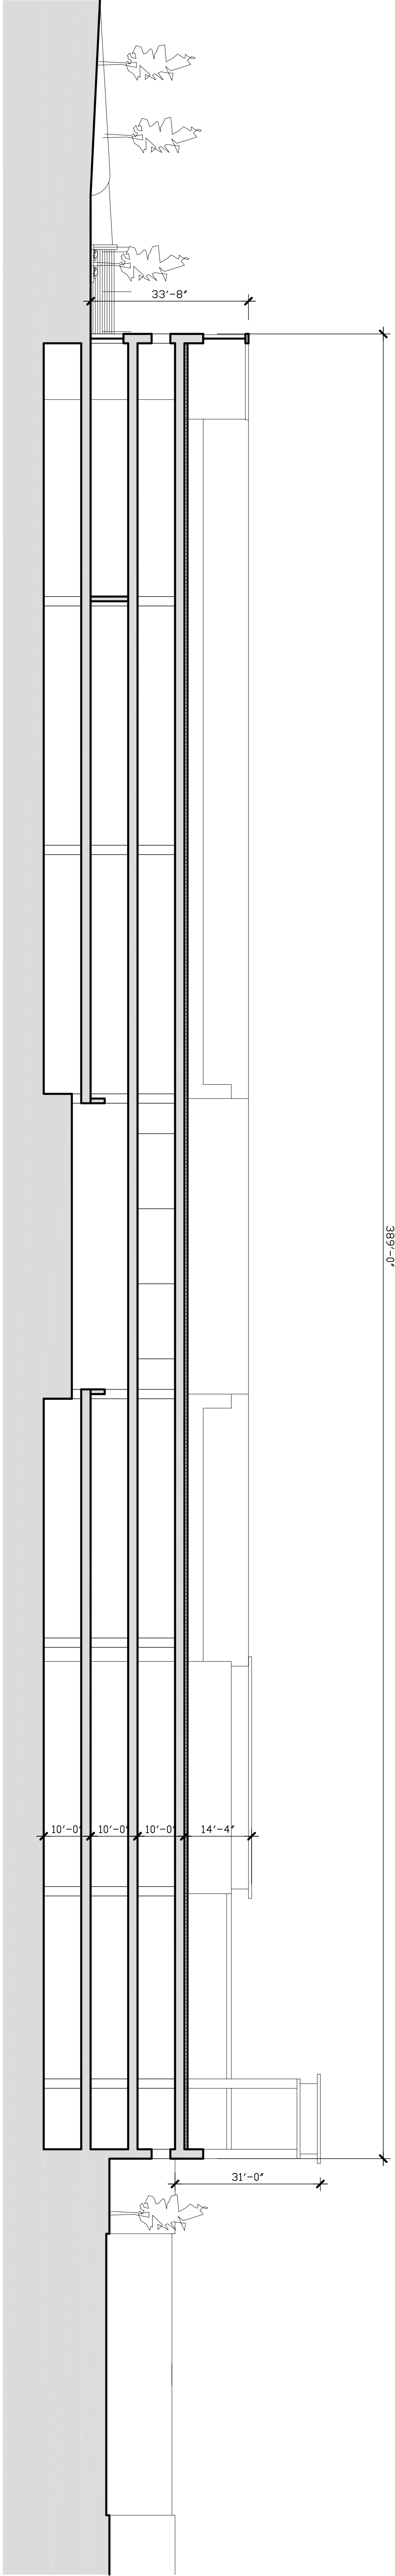

NORTH/SOUTH SECTION

1/8" = 1'-0"

1