

MINIMUM 12" VENT FROM CURB TO TOP OF ROOF IN THE CITY OF MILWAUKEE, WISCONSIN. WITH 24" OF INSULATION BELOW THE ROOF IN THE CITY OF MILWAUKEE, WISCONSIN. 24" OF INSULATION BELOW THE ROOF IN THE CITY OF MILWAUKEE, WISCONSIN. 24" OF INSULATION BELOW THE ROOF IN THE CITY OF MILWAUKEE, WISCONSIN.

THIS PLAN IS NOT TO BE USED FOR ANY OTHER PURPOSES WITHOUT THE WRITTEN CONSENT OF THE ENGINEER.


HARRY S. GLUSCH
INSPECTOR OF BUILDINGS
MILWAUKEE, WIS.

PLAN 10000 10-1-62
REVISED 10-1-62

THIS REMOVAL DOES NOT INCLUDE MECHANICAL BRANCHES

FINISHING SCHEDULE								
ROOM	FLOOR	CEILING	WALLS	TRIM	DOORS	BASES	CEILING	WAINSCOTING
GRAND	1ST	EXPOSED	EXPOSED	None	None	None		
UPPER HALL	1ST	ASPHALT	ASPHALT	PIPE	None	None		
LOWER HALL	1ST	ASPHALT	ASPHALT	PIPE	None	None		
OFFICE	1ST	ASPHALT	ASPHALT	PIPE	None	None		
"	2ND	ASPHALT	ASPHALT	PIPE	None	None		
"	3RD	ASPHALT	ASPHALT	PIPE	None	None		
"	4TH	ASPHALT	ASPHALT	PIPE	None	None		
BASEMENT	1ST	EXPOSED	EXPOSED	None	None	None		
BASEMENT	2ND	EXPOSED	EXPOSED	None	None	None		

NOTE:
ALL DRAINAGE TO BE AS MANUFACTURED BY "POLY-CLAD PLYWOOD"

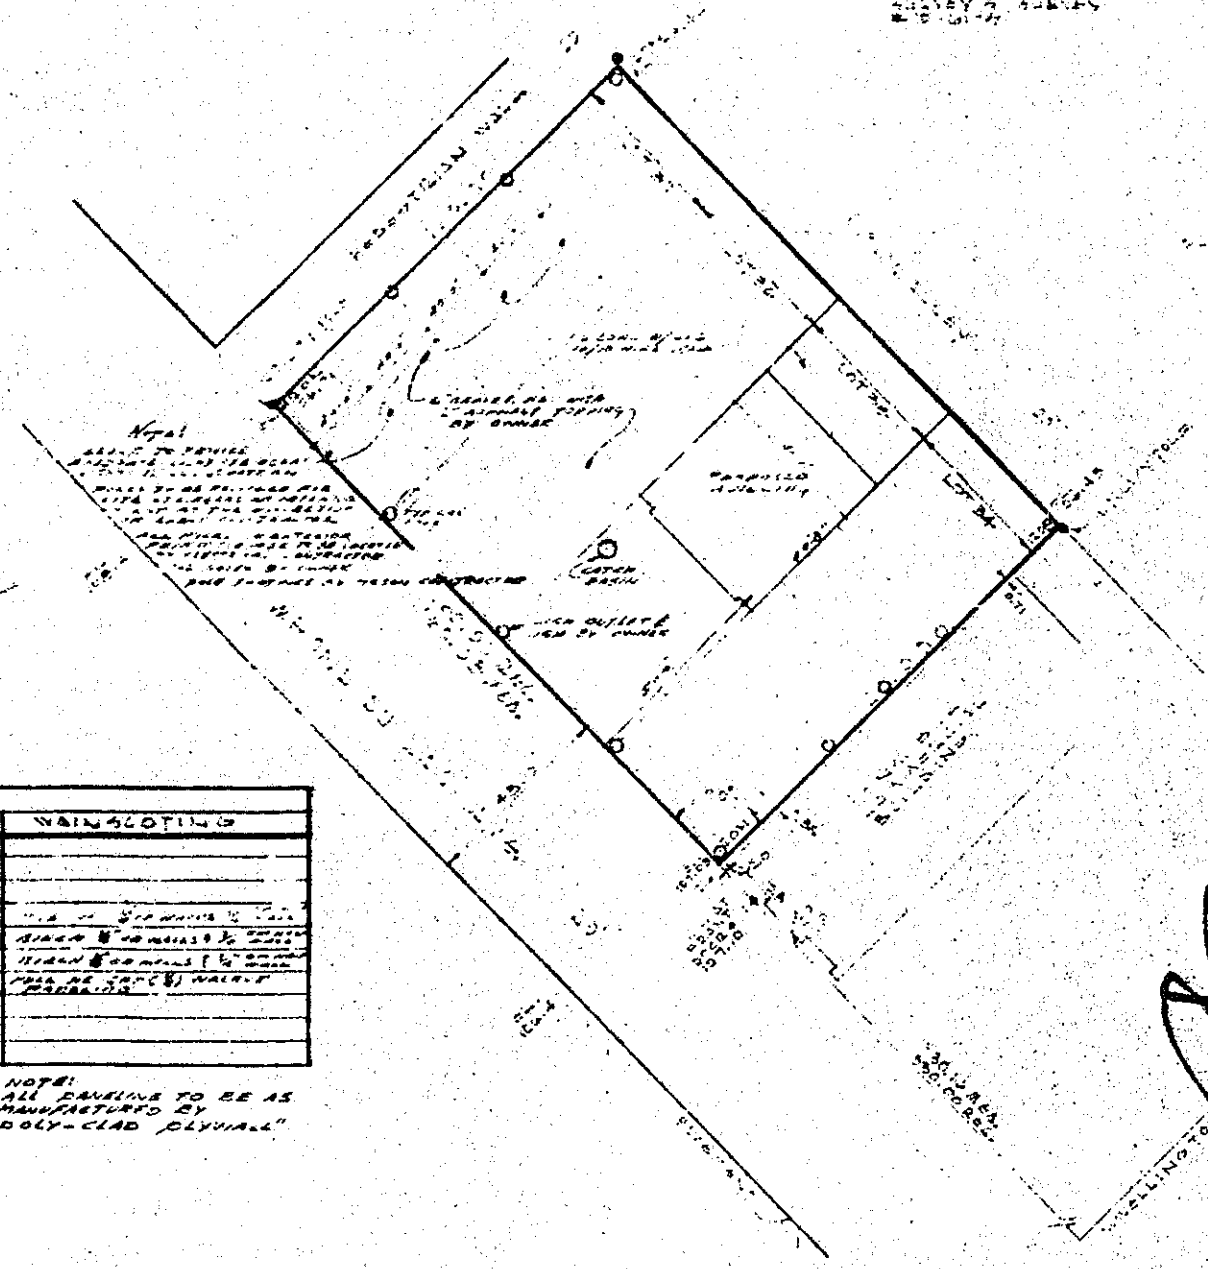

PLOT PLAN

[Handwritten signature]

OFFICE - GARAGE
7222 W. FONDULAC

THIS PLAN IS DESIGNED TO CONFORM TO THE STANDARDS OF ALL CODES APPLICABLE TO THIS PARTICULAR STRUCTURE AND IS FURNISHED BY REQUEST ONLY. LIABILITY FOR ANY ERRORS OR OMISSIONS WHICH MAY OCCUR HEREIN IS REMOVED FROM JERRY SLEETER & ASSOCIATES AS A CONDITION OF ACCEPTANCE OF THIS DRAWING. THIS PLAN HAS BEEN DESIGNED AND DRAWN EXCLUSIVELY FOR THE PARTY NAMED IN THE TITLE BLOCK AND MAY NOT BE REPRODUCED IN WHOLE OR IN PART BY ANY METHOD WITHOUT THE WRITTEN CONSENT OF THE NAMED PARTY.



DESIGNED FOR MR. NATE BORKHO




JERRY SLEETER & ASSOCIATES

6826 WEST CAPITOL DRIVE
MILWAUKEE, WISCONSIN
MILWAUKEE 4, WISCONSIN

REVISIONS	DATE	DRAWING NO.
10/9/62		6826

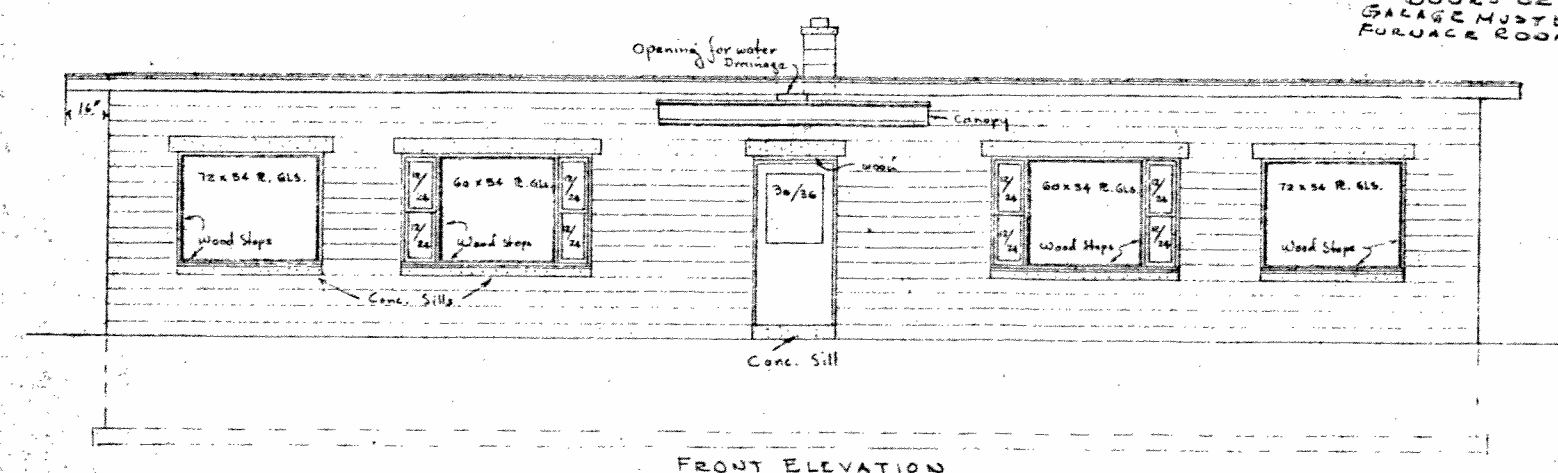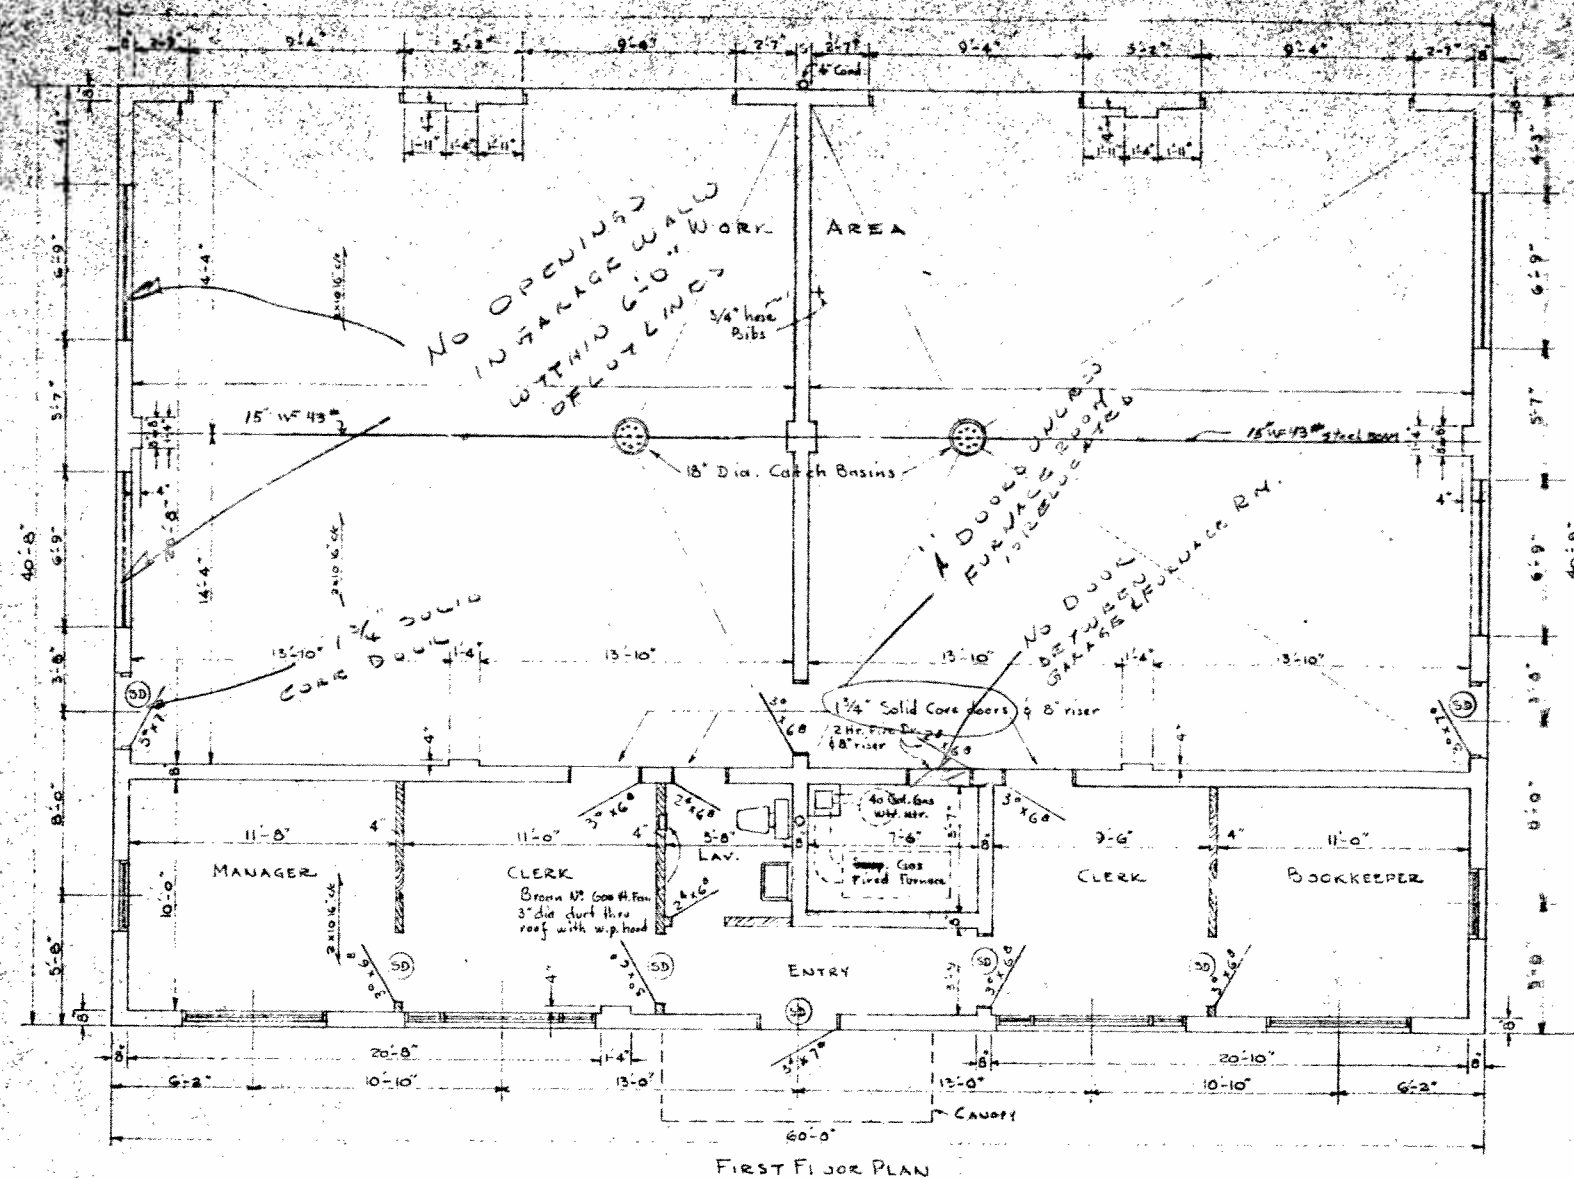

27/64
WINDOWS IN WEST WALL
PROHIBITED, DOOR BETWEEN FURNACE
AND GARAGE
DOOR BETW
GARAGE MUST BE
FURNACE ROOM

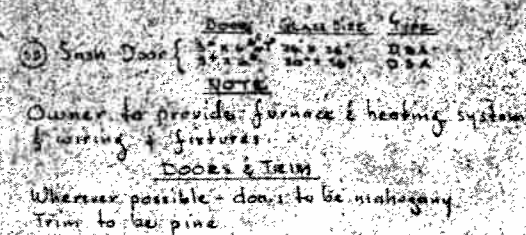

FLOORS

WORK AREA: 4" Conc. 6 x 6 10" mesh
BALANCE: 4" Conc. no mesh

DRYWALL

All wood stud partitions & Lav. ceiling
to receive 1/2" drywall taped & spackled

ACOUSTICAL CEILING




Four offices & ENTRY to have 3/8" sheetrock

PLASTERING

HEATER ROOM ceiling to receive 1" cement plaster on metal lath

PLUMBING FIXTURES

WATER CLOSET: Kohler Wellworth
K-5712-EBA with open front seat
LAVATORY: Kohler 19" x 17" Hampton
K-2701-A Less Towel Bars.

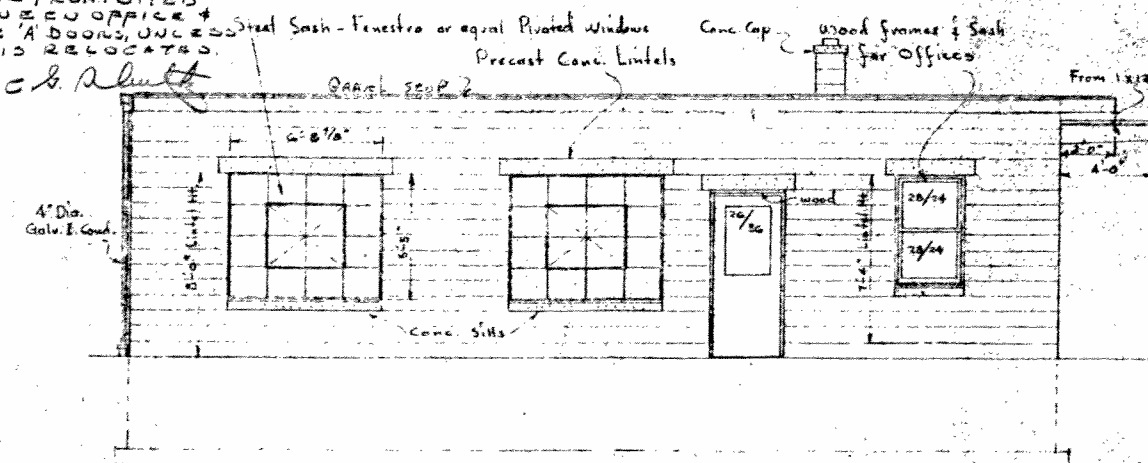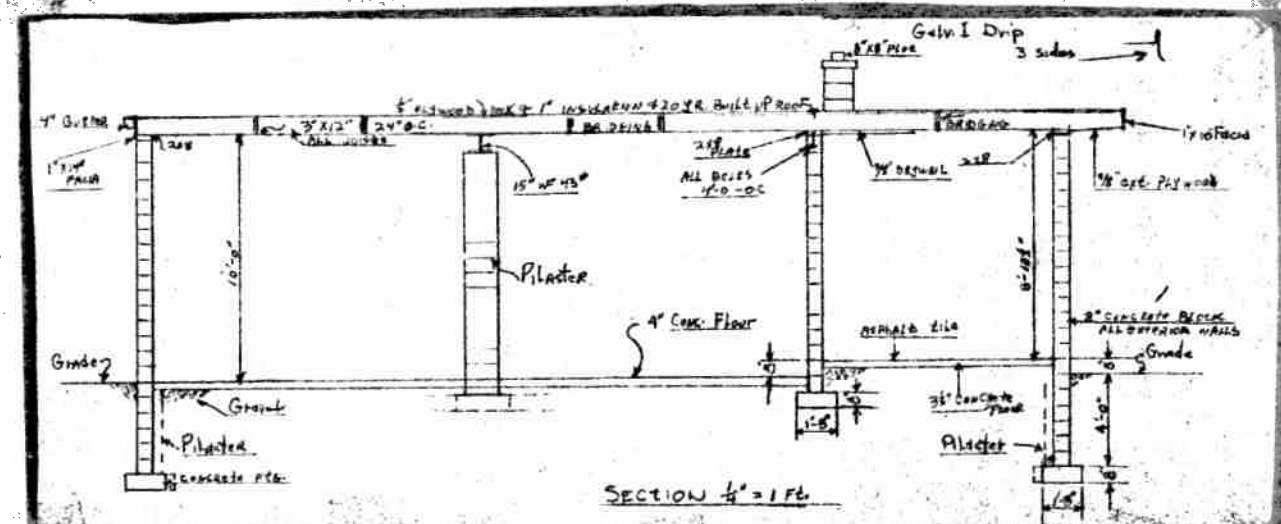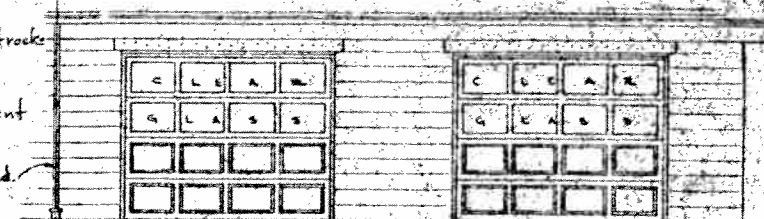

STORAGE

2/3

7318 W. FORD DR LAG.

212-0292-100


60'

This area has p/s a/g.
2- hoists
1 air comp.

wood roof
Steel I beam

the area
2 hoists
p/s a/g

8" R.R.

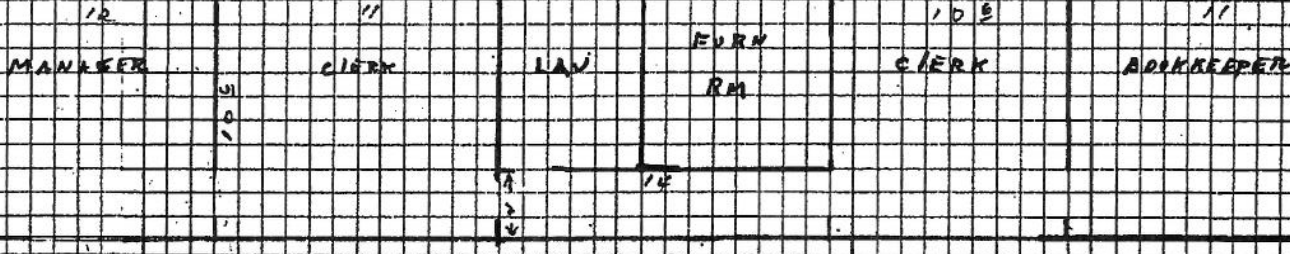

8" CONC. BIK